


# POST FRAMED STORAGE BUILDING

R&R DRAFTING  
llc.



29130 Taylor Rd  
Dennison, Ohio 44621  
Phone 330-440-2717  
Email rrdrafting@yahoo.com

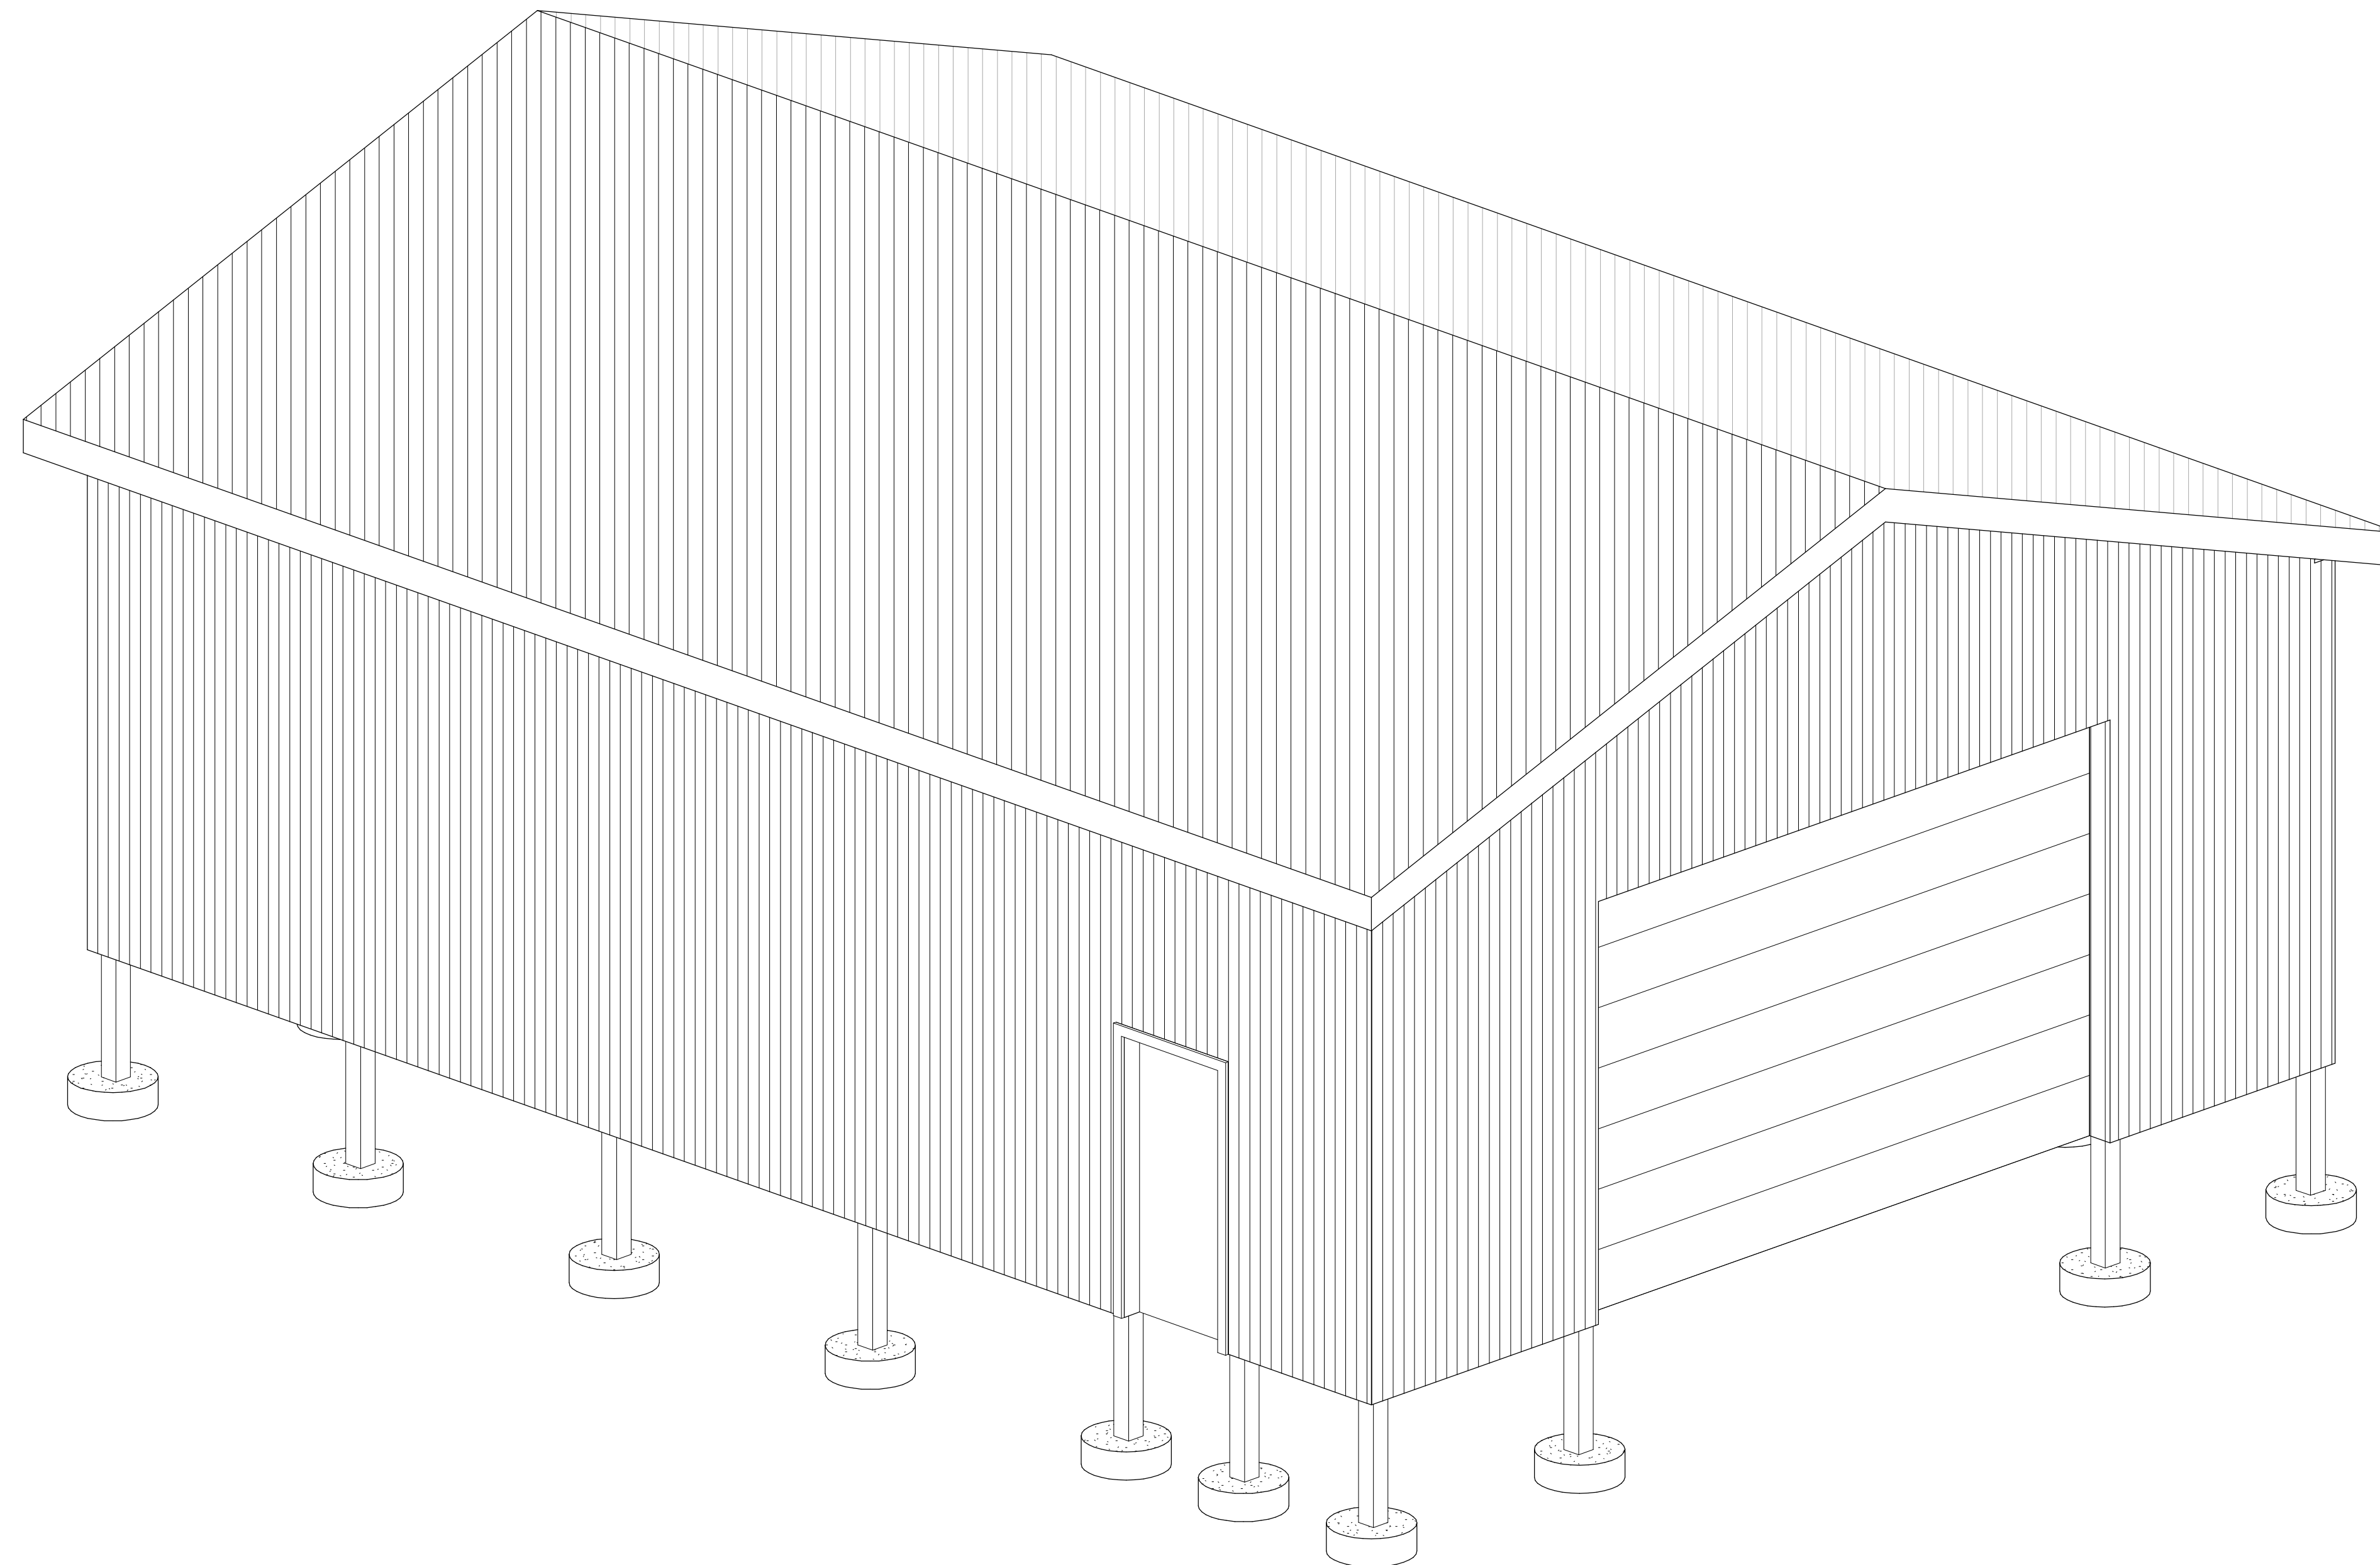


① 3D Cover

No.	Description	Date
	50% Review Plans	07/03/2018


<b>Cover/Site</b>	
Project number	Project Number
Date	04/26/2016
Drawn by	Author
Checked by	Checker
<b>A000</b>	
Scale	



29130 Taylor Rd  
Dennison, Ohio 44621  
Phone 330-440-2717  
Email rrdrafting@yahoo.com

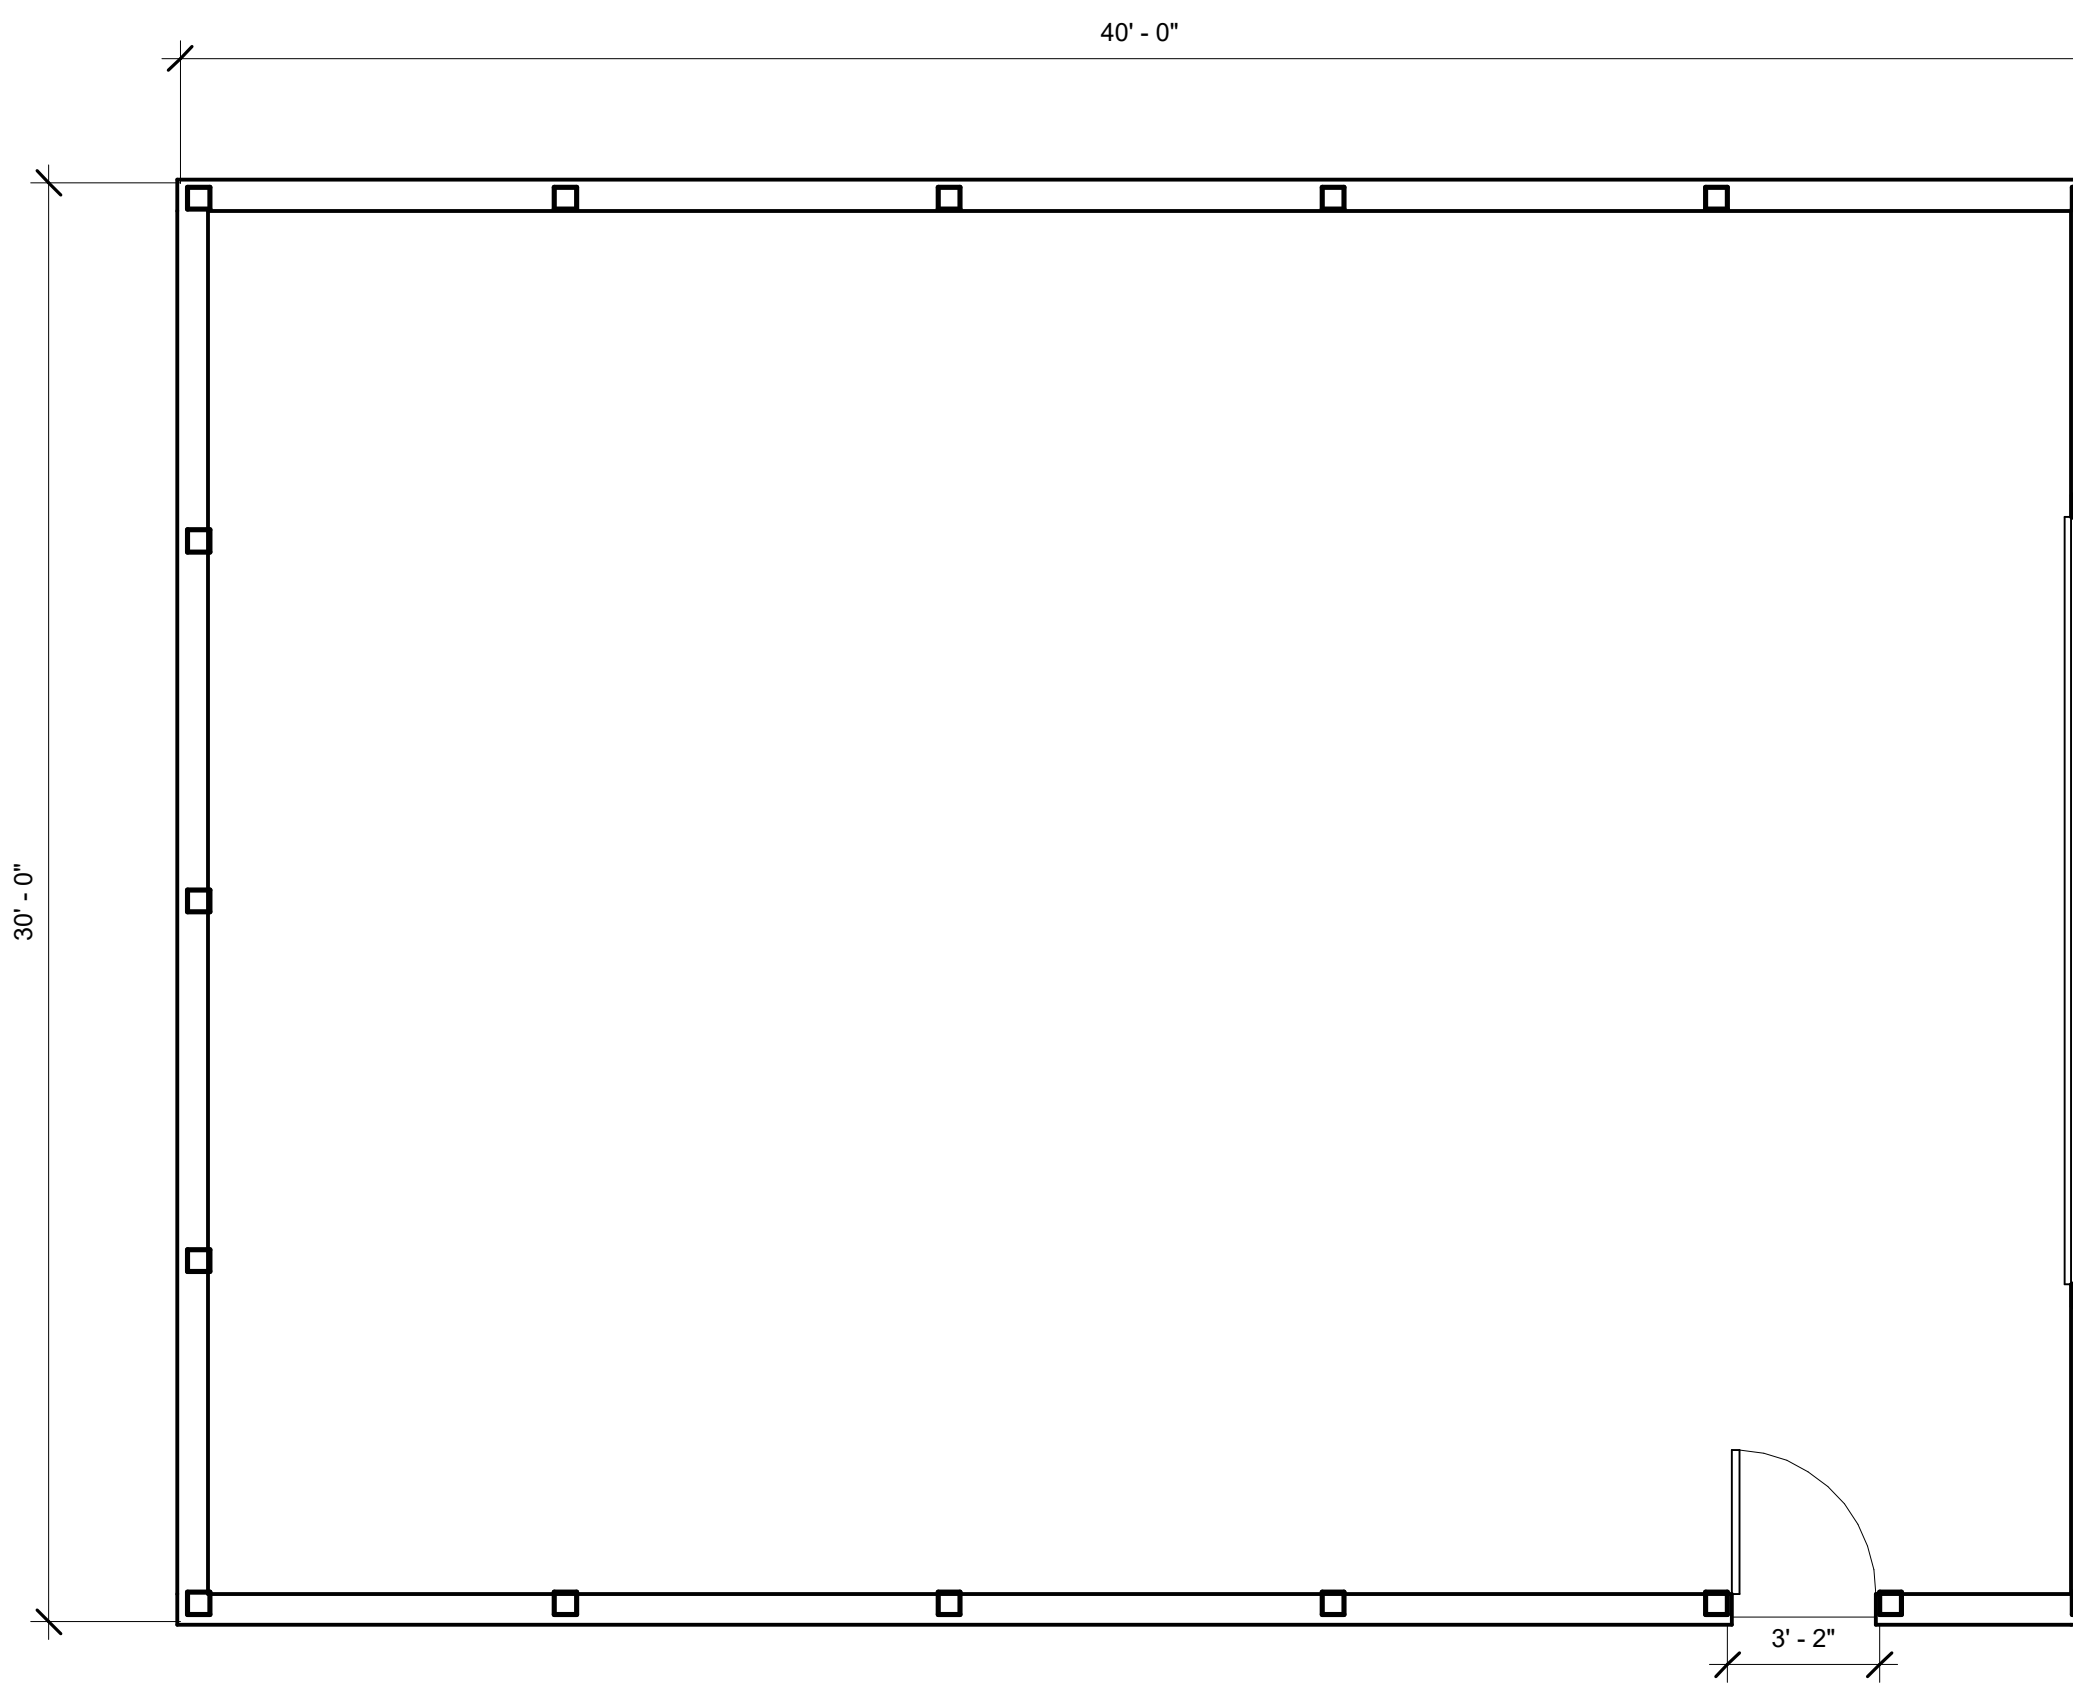

① Floor Plan  
1/4" = 1'-0"

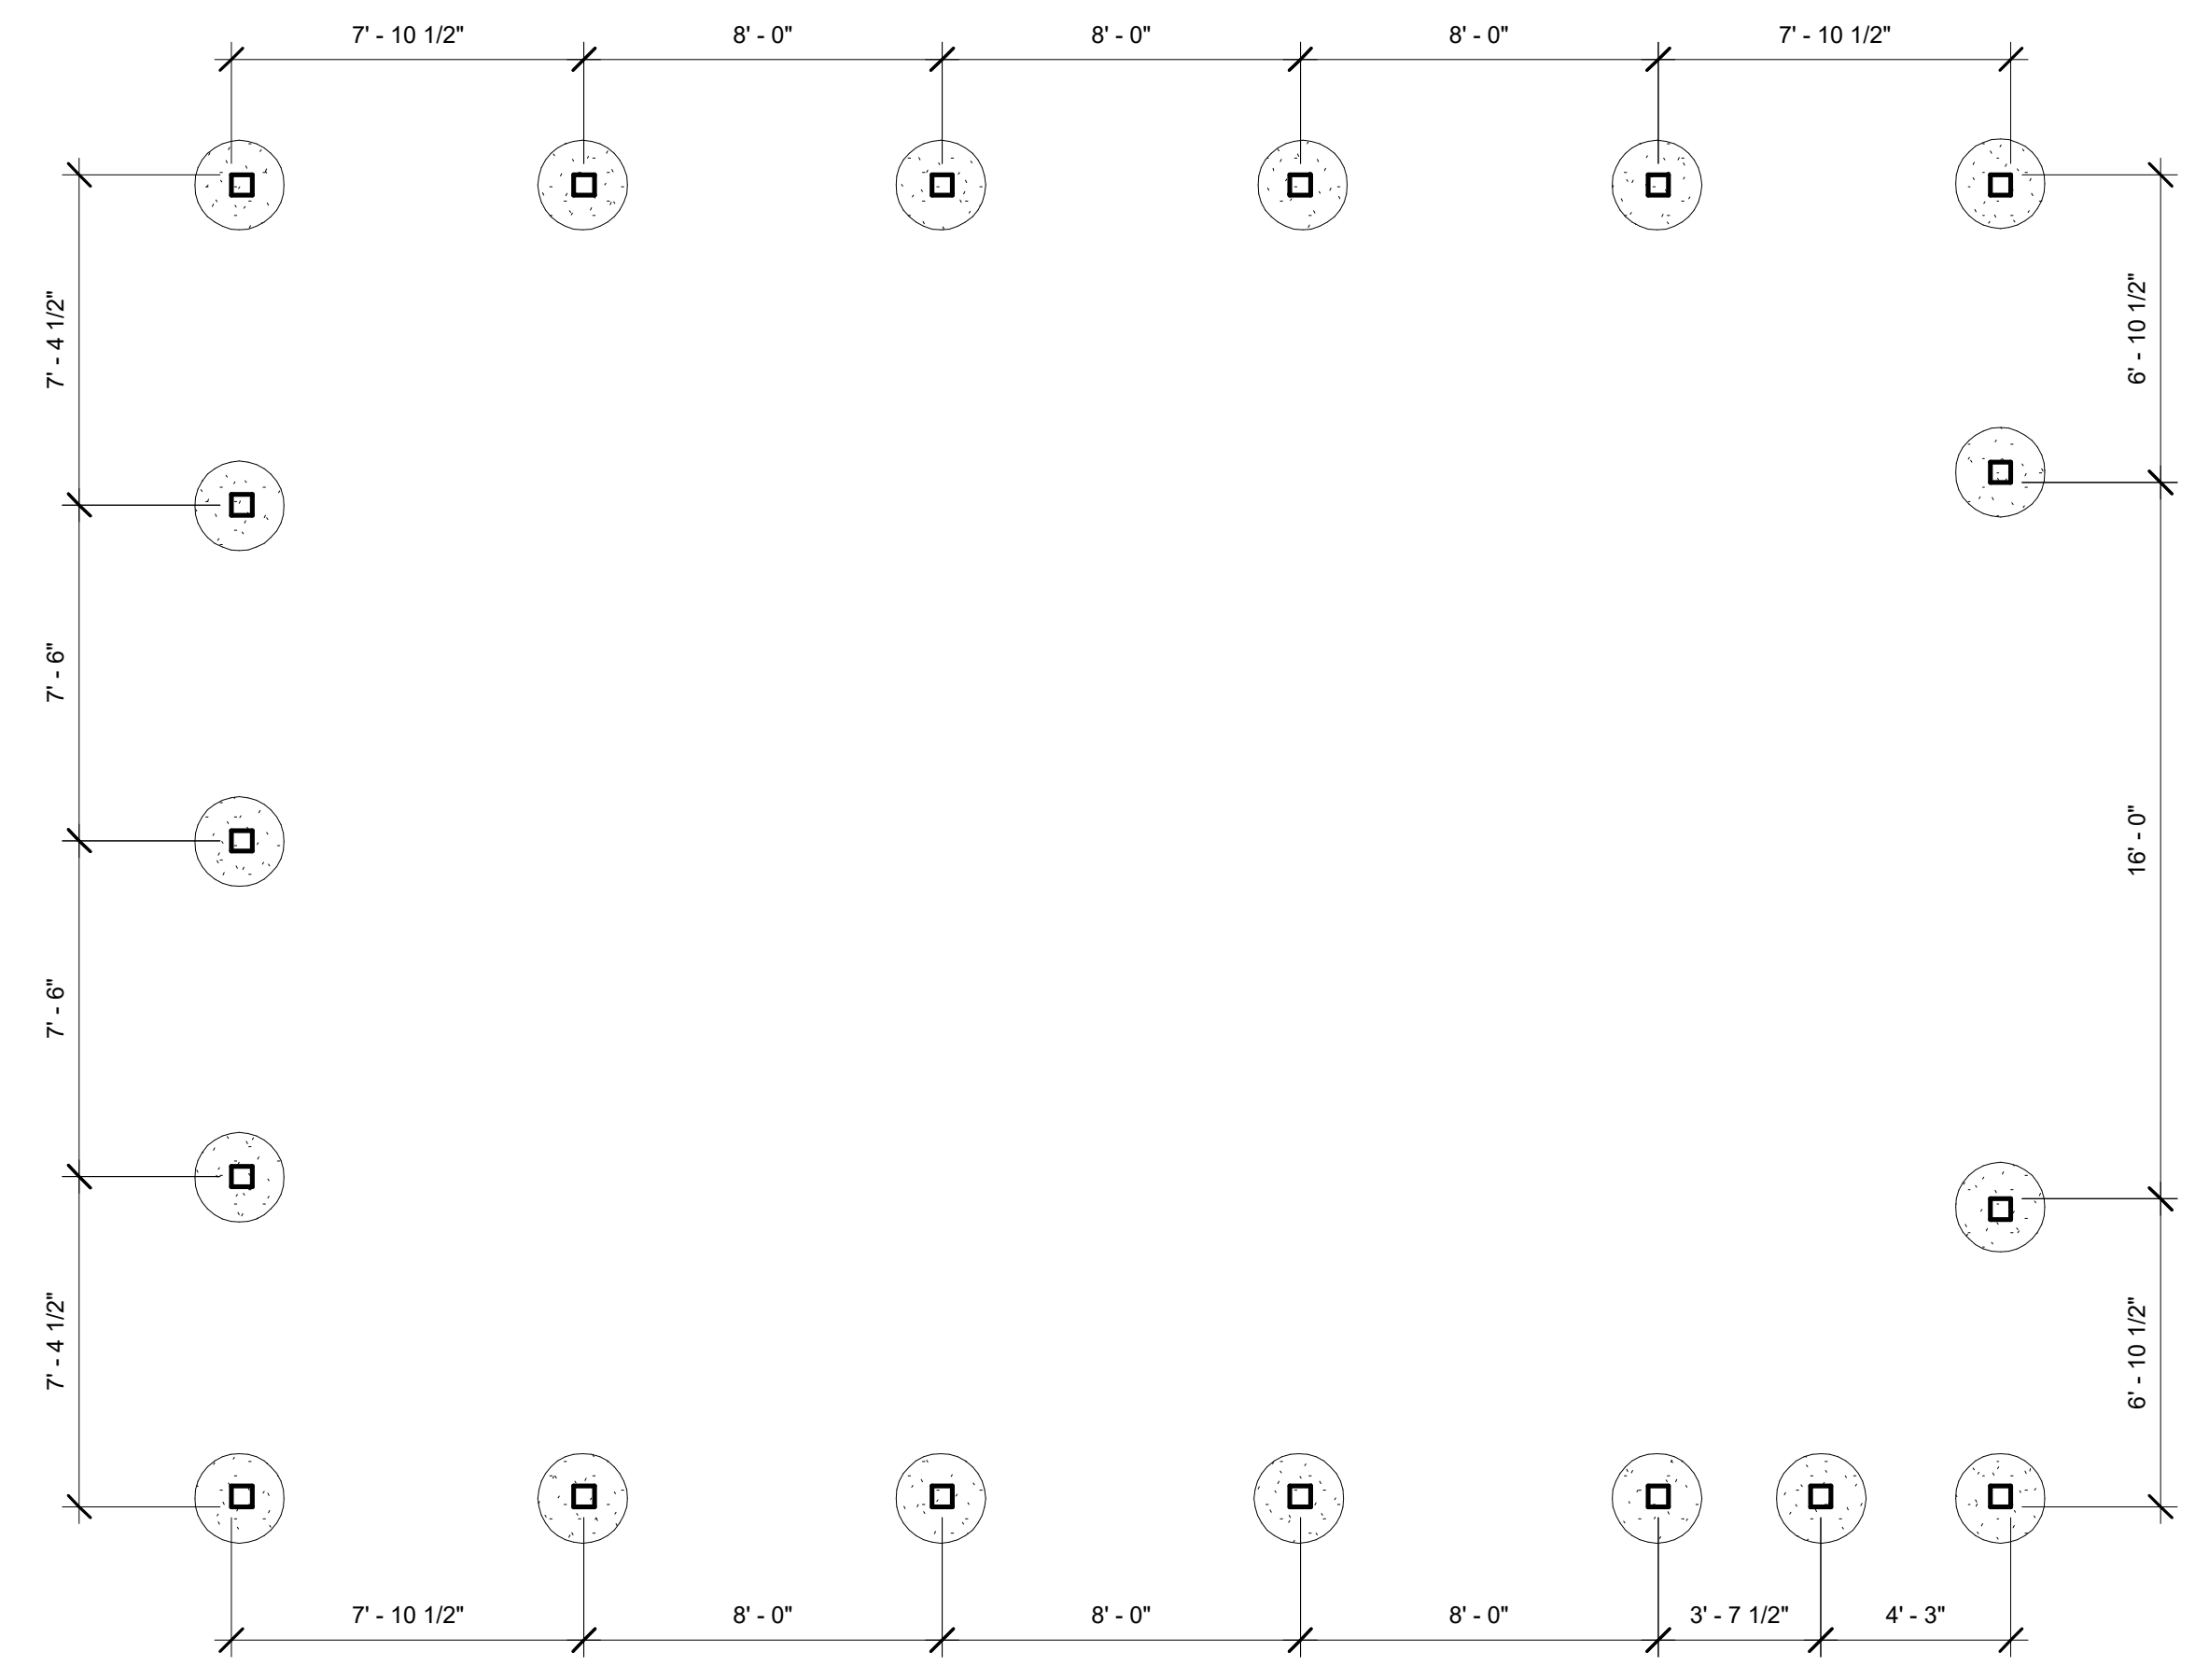

② Foundation Plan  
1/4" = 1'-0"

No.	Description	Date
	50% Review Plans	07/03/2018

Foundation/Floor Plan





Project number	Project Number
Date	04/26/2016
Drawn by	RJR
Checked by	JM

**A100**

Scale 1/4" = 1'-0"



29130 Taylor Rd  
Dennison, Ohio 44621  
Phone 330-440-2717  
Email rrdrafting@yahoo.com

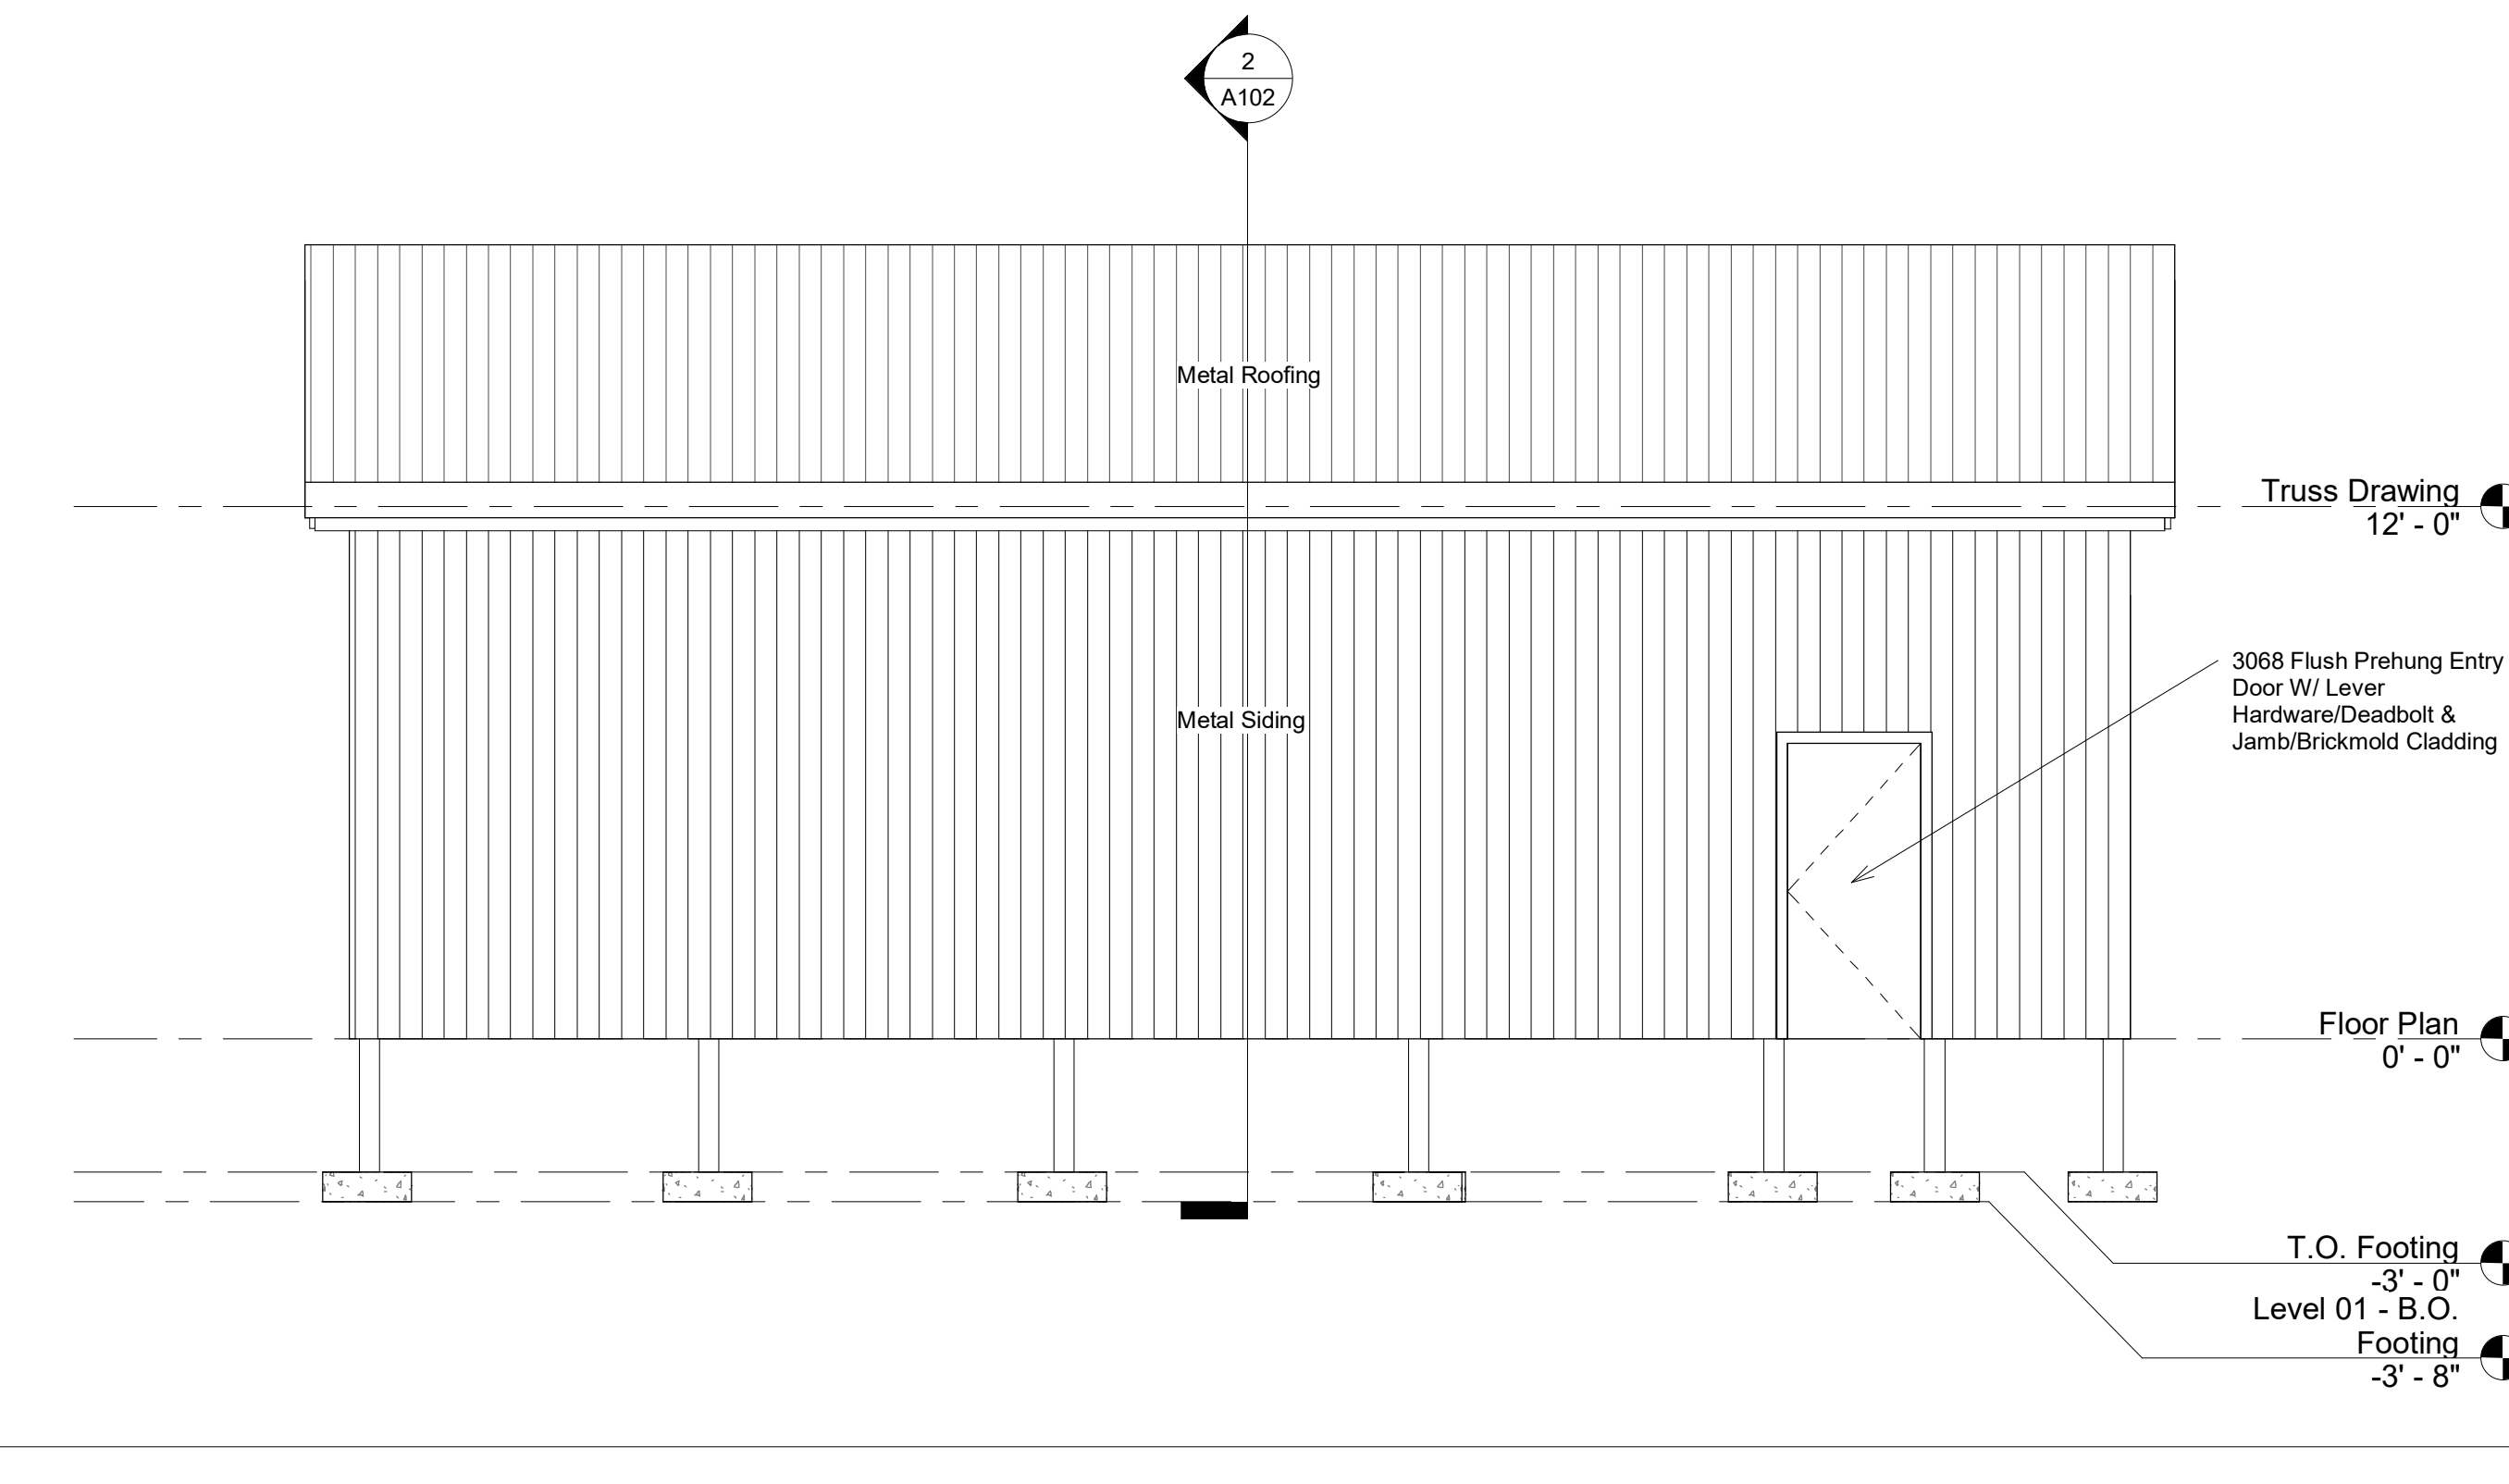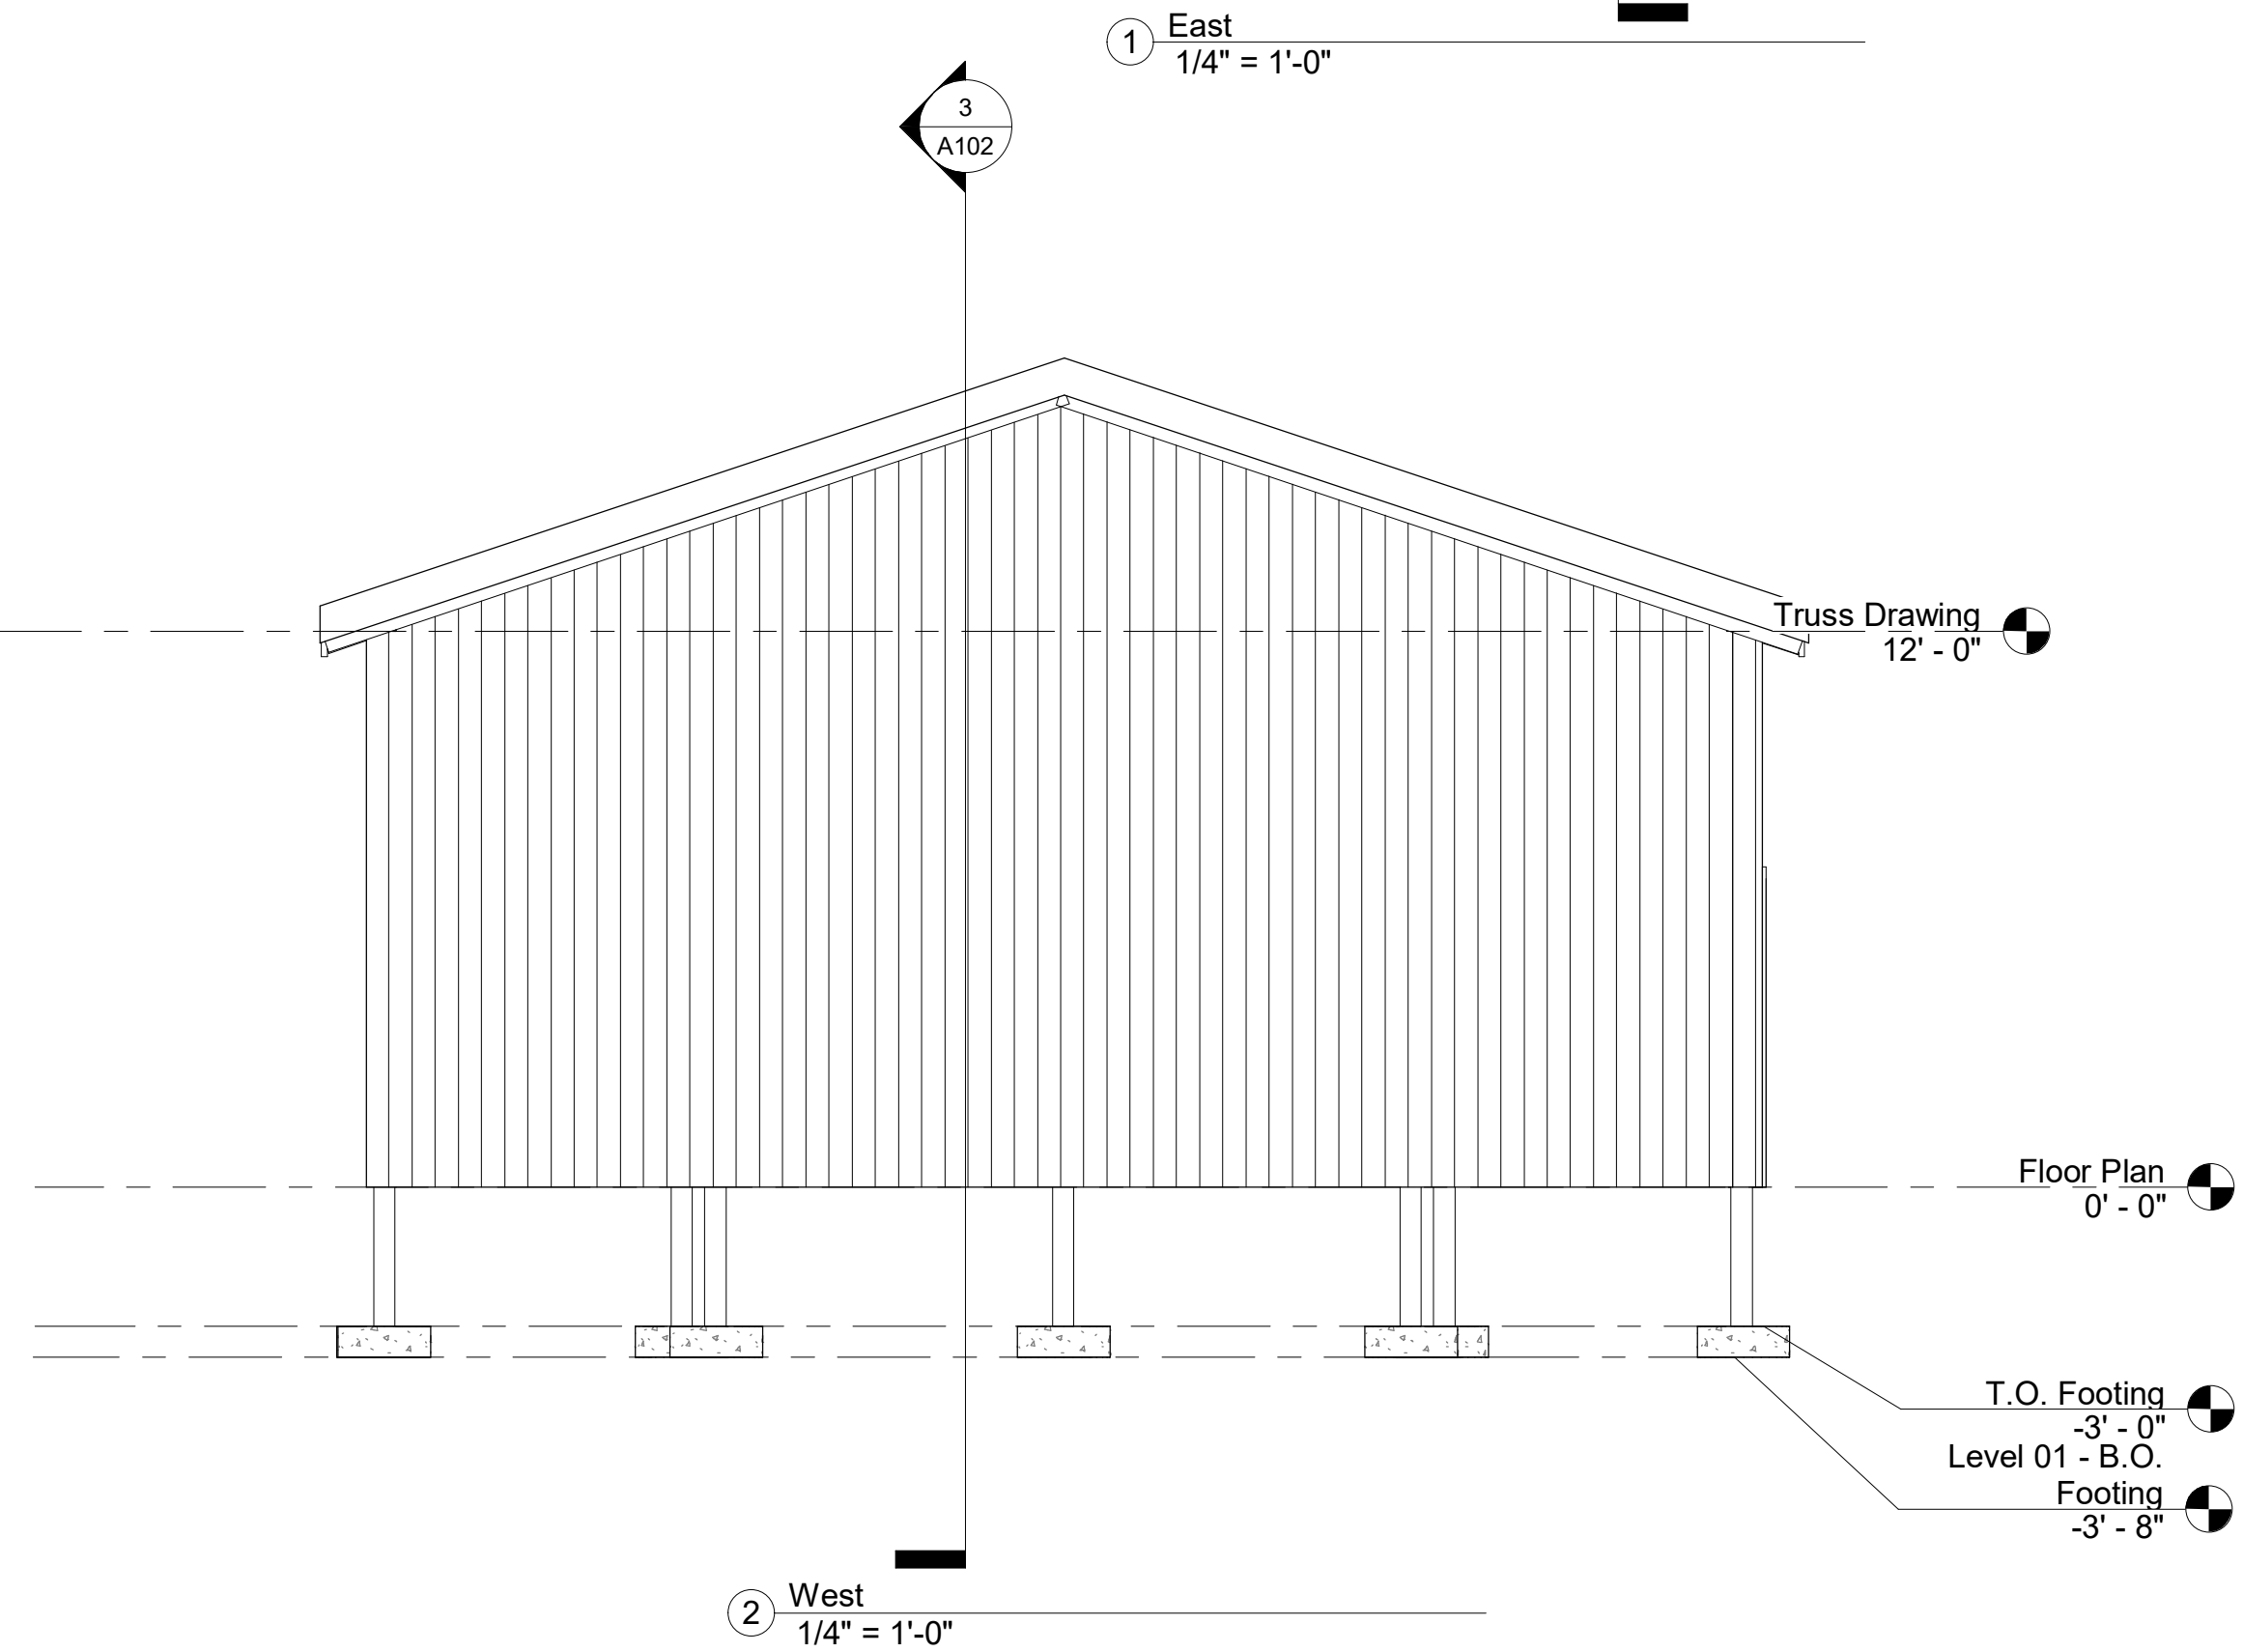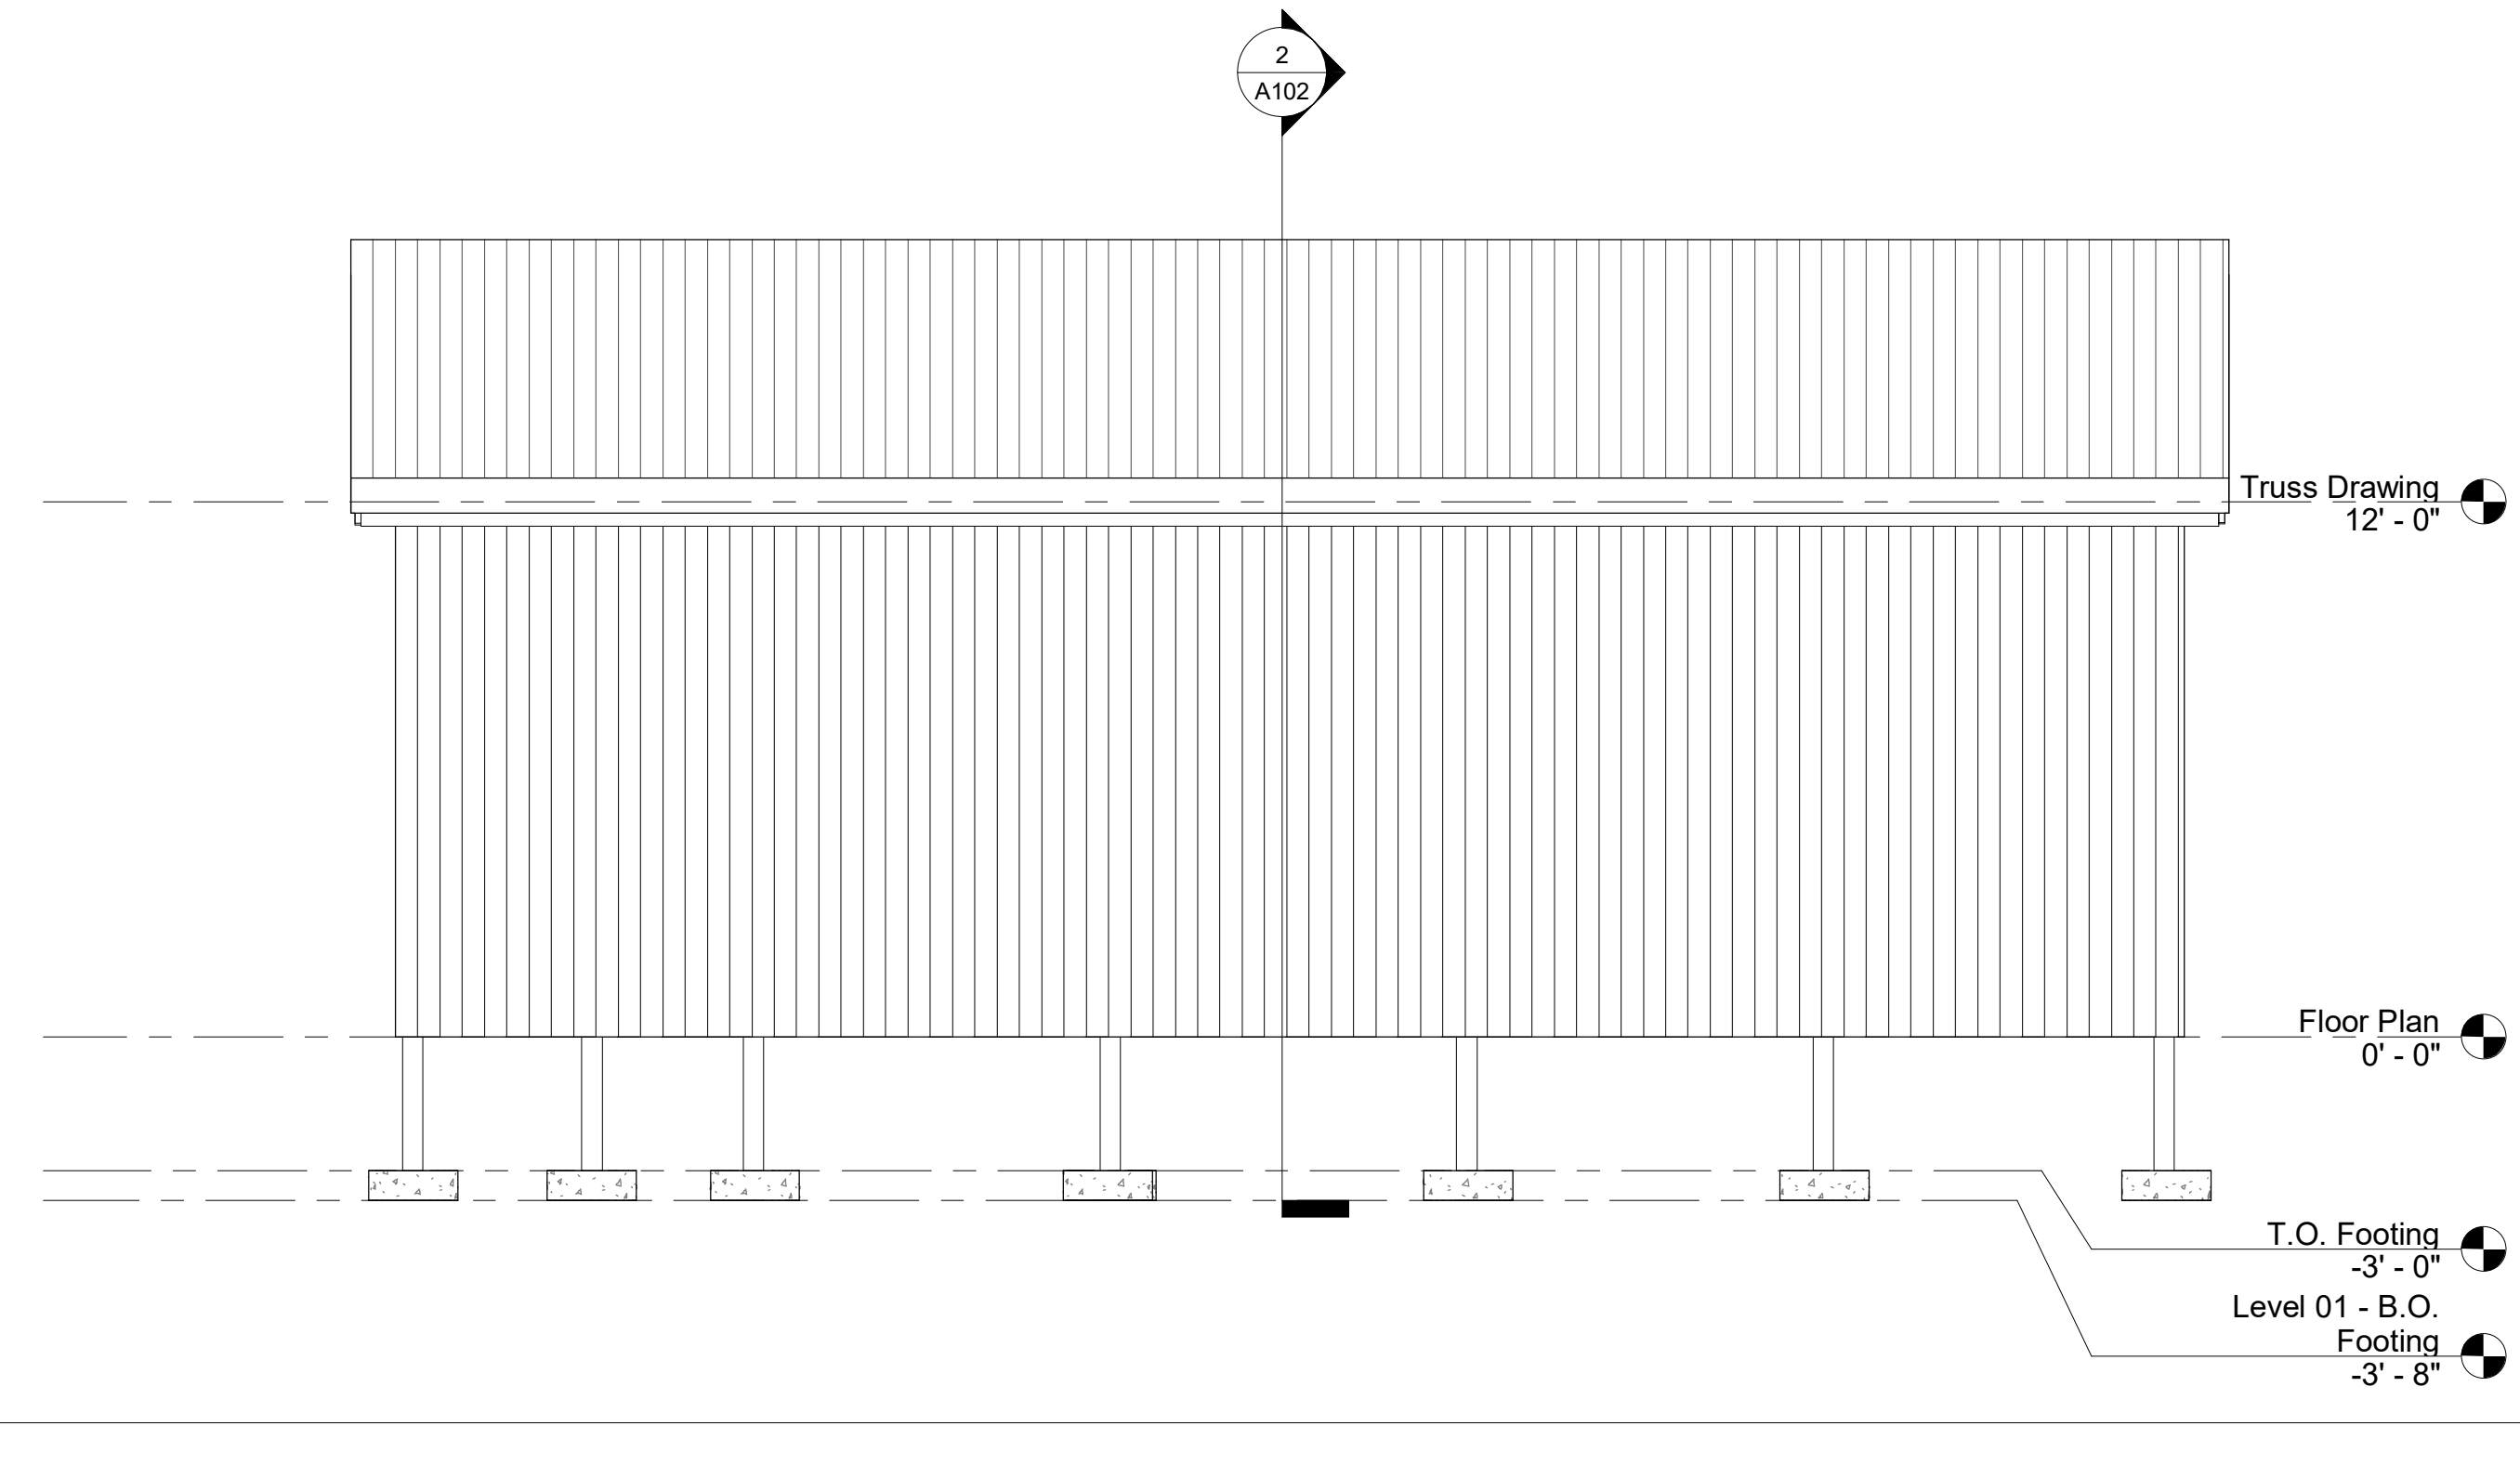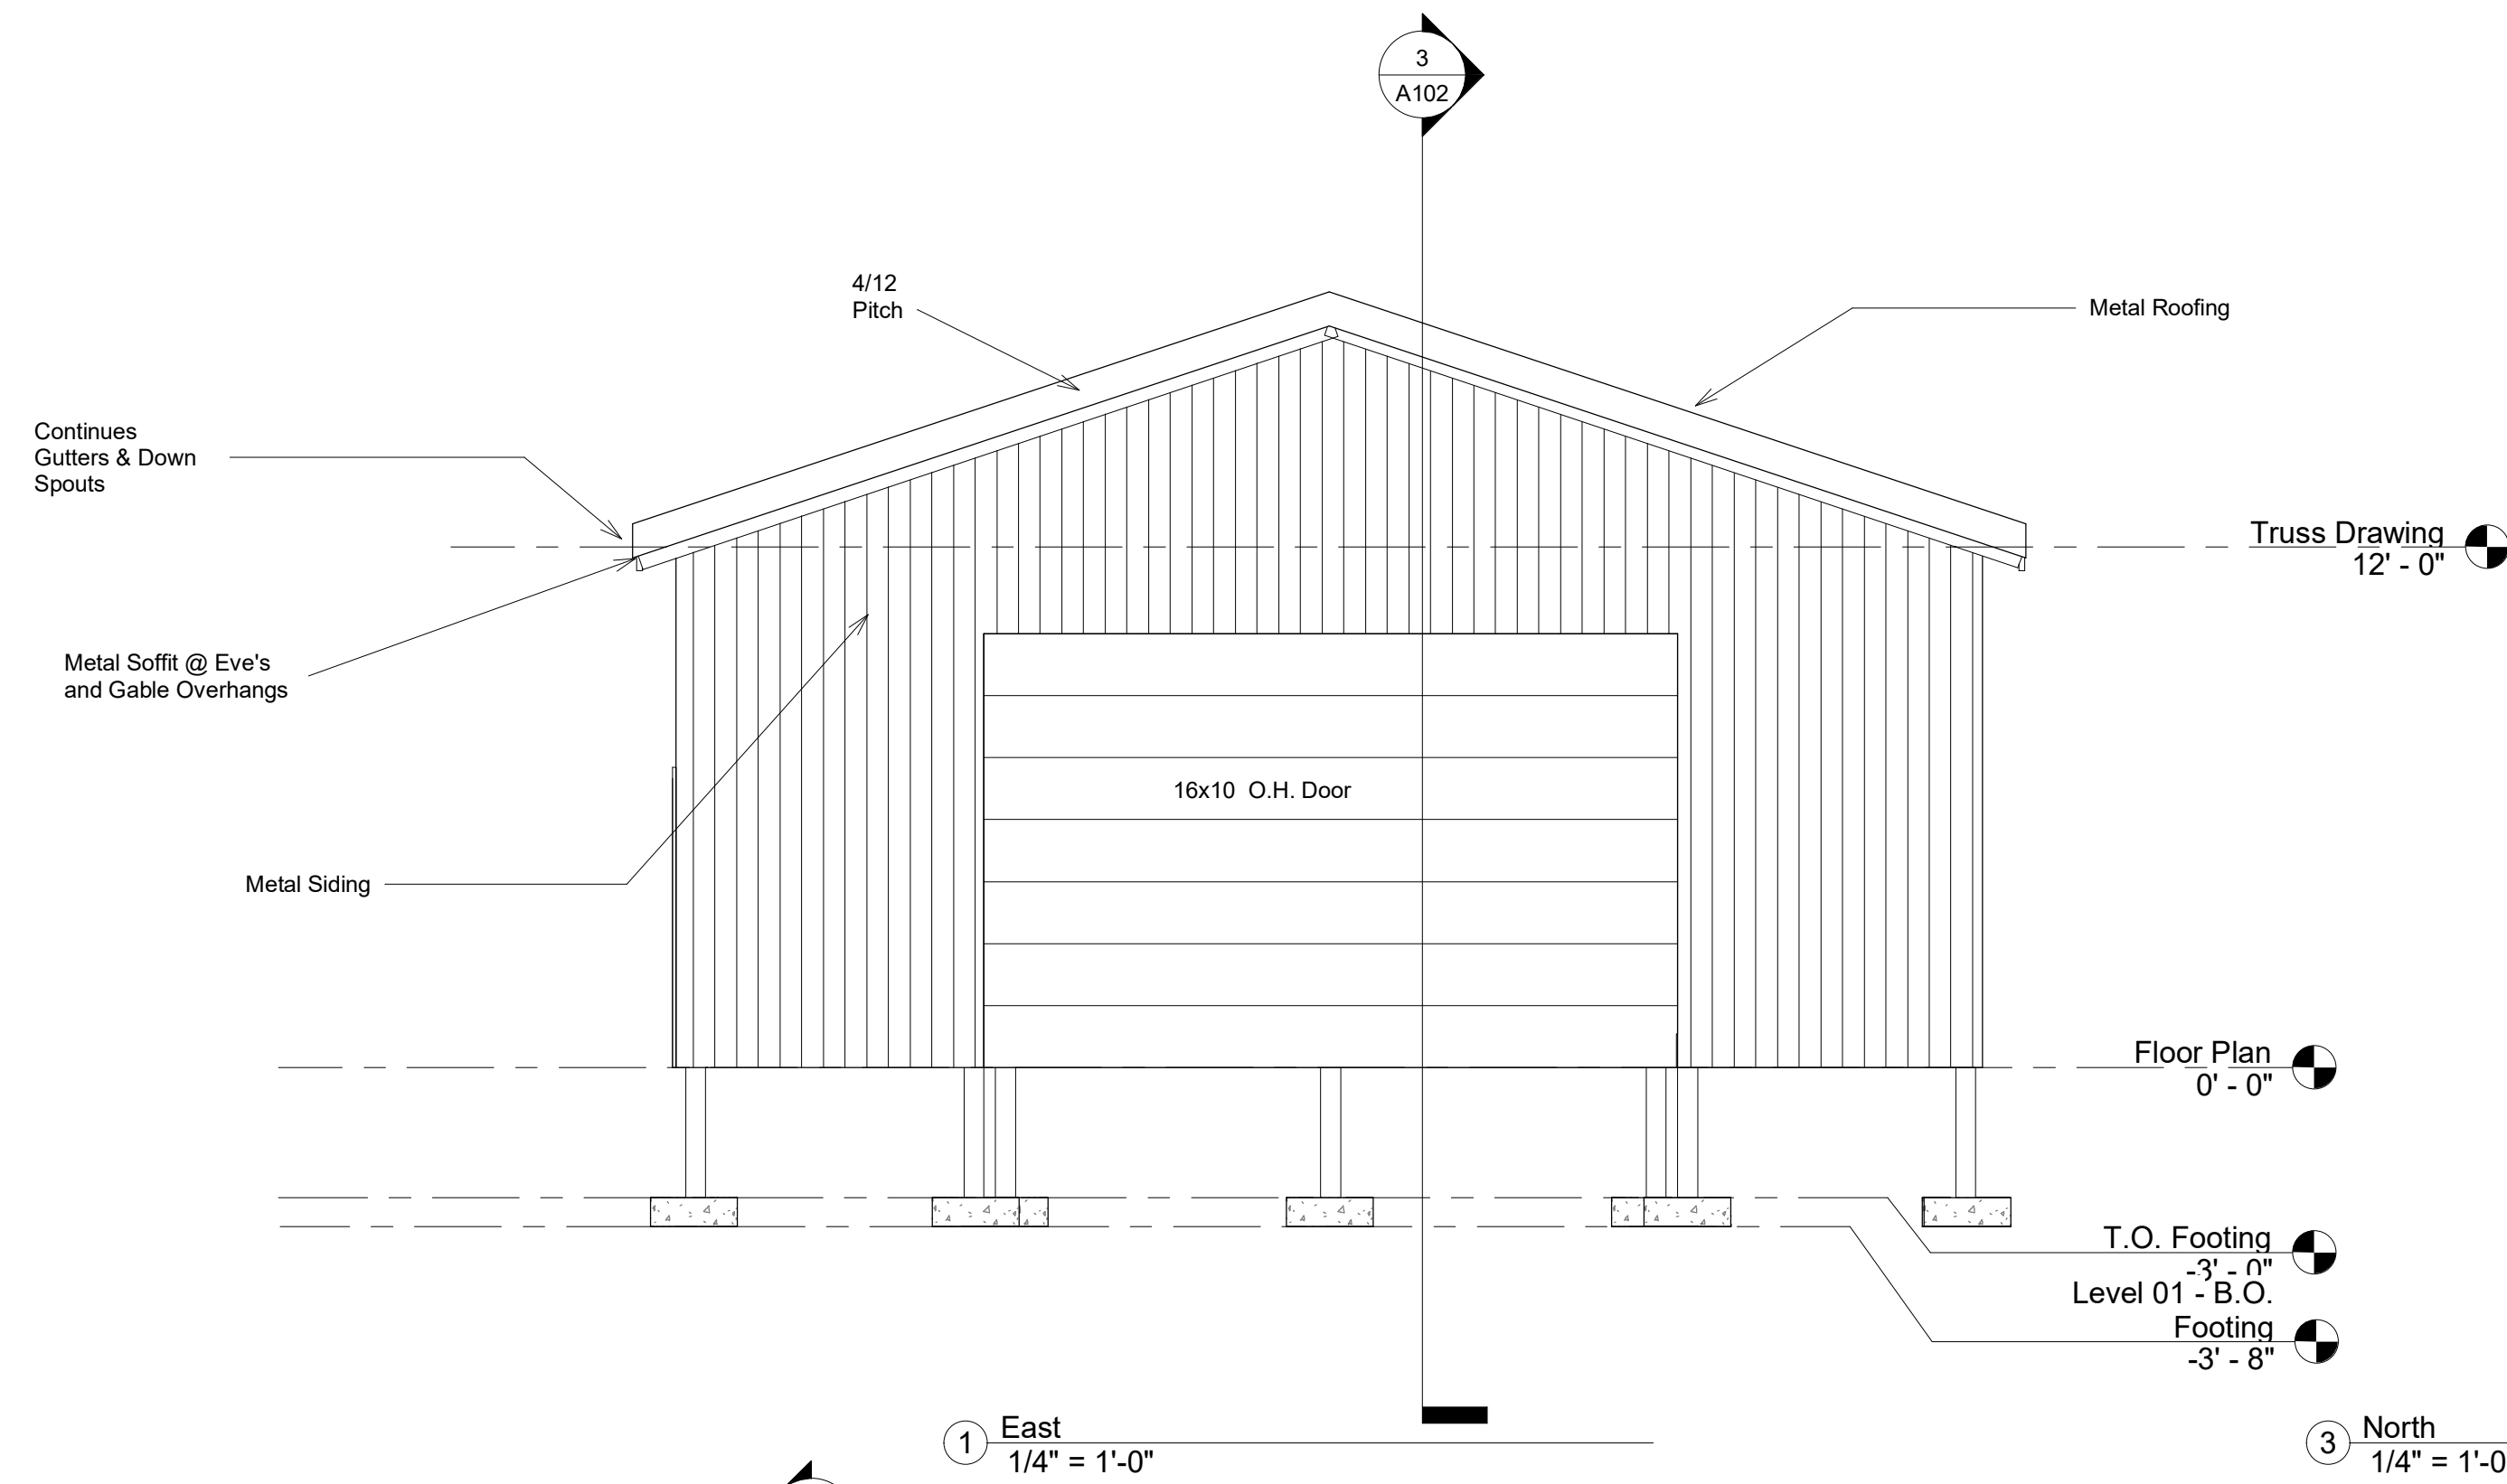

No.	Description	Date
	50% Review Plans	07/03/2018

**Elevations**


Project number	<b>Project Number</b>
Date	<b>04/26/2016</b>
Drawn by	<b>Author</b>
Checked by	<b>Checker</b>

**A101**


Scale:  $1/4" = 1'-0"$

1/12/2019 12:43:43 PM



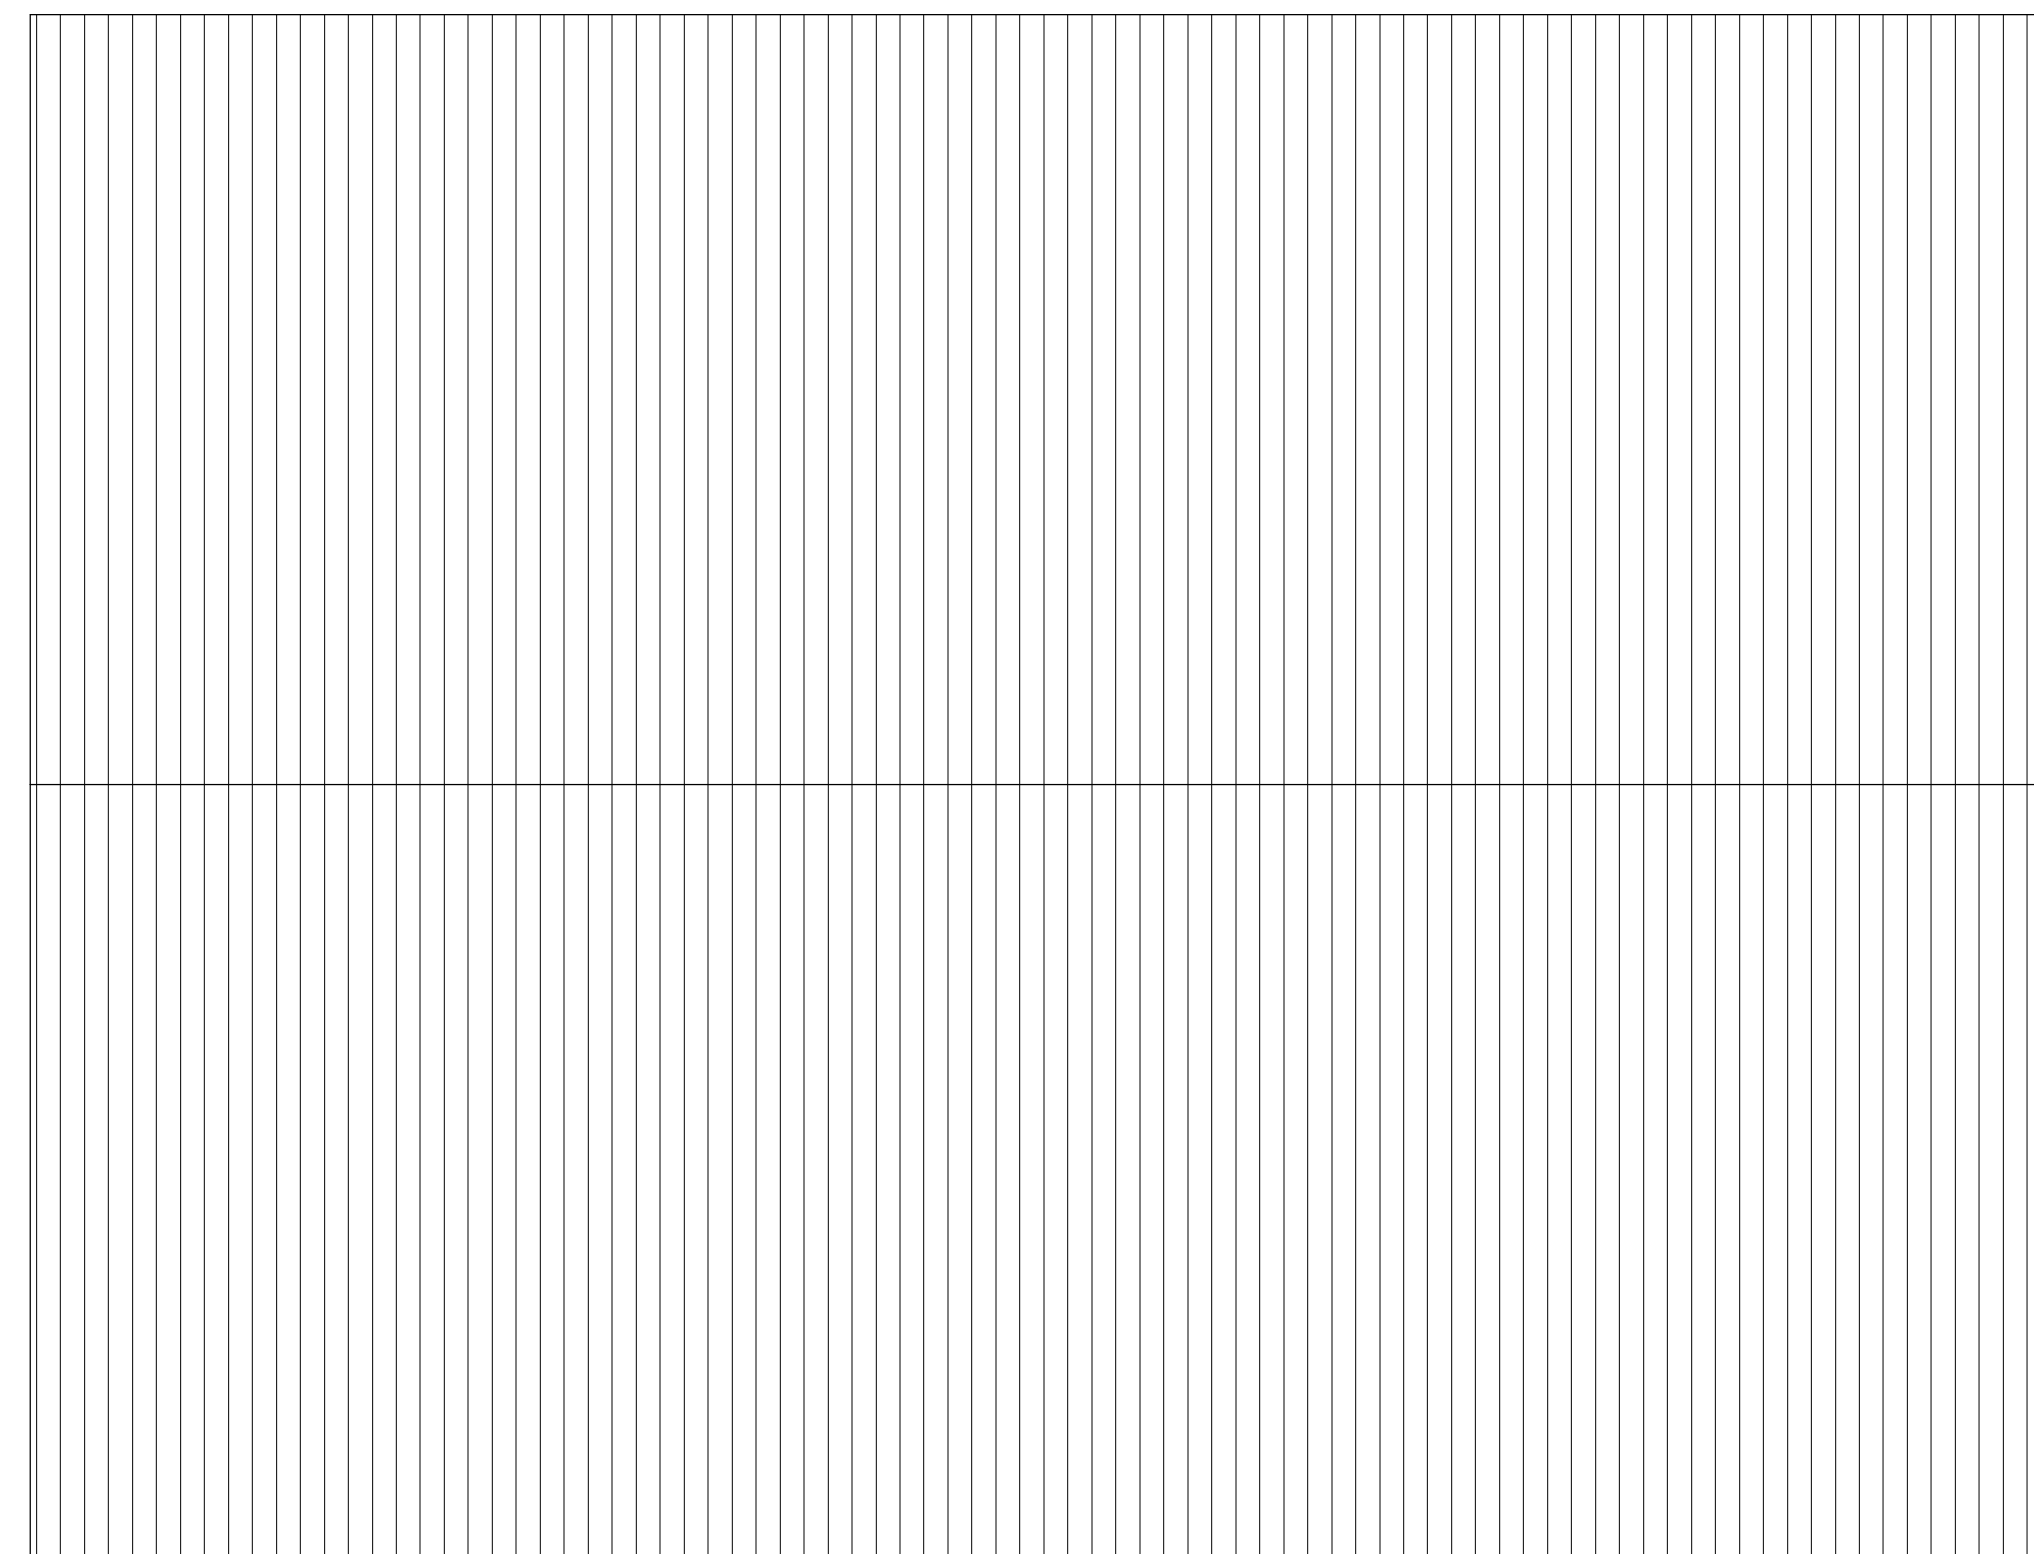

① Roof Plan  
1/4" = 1'-0"

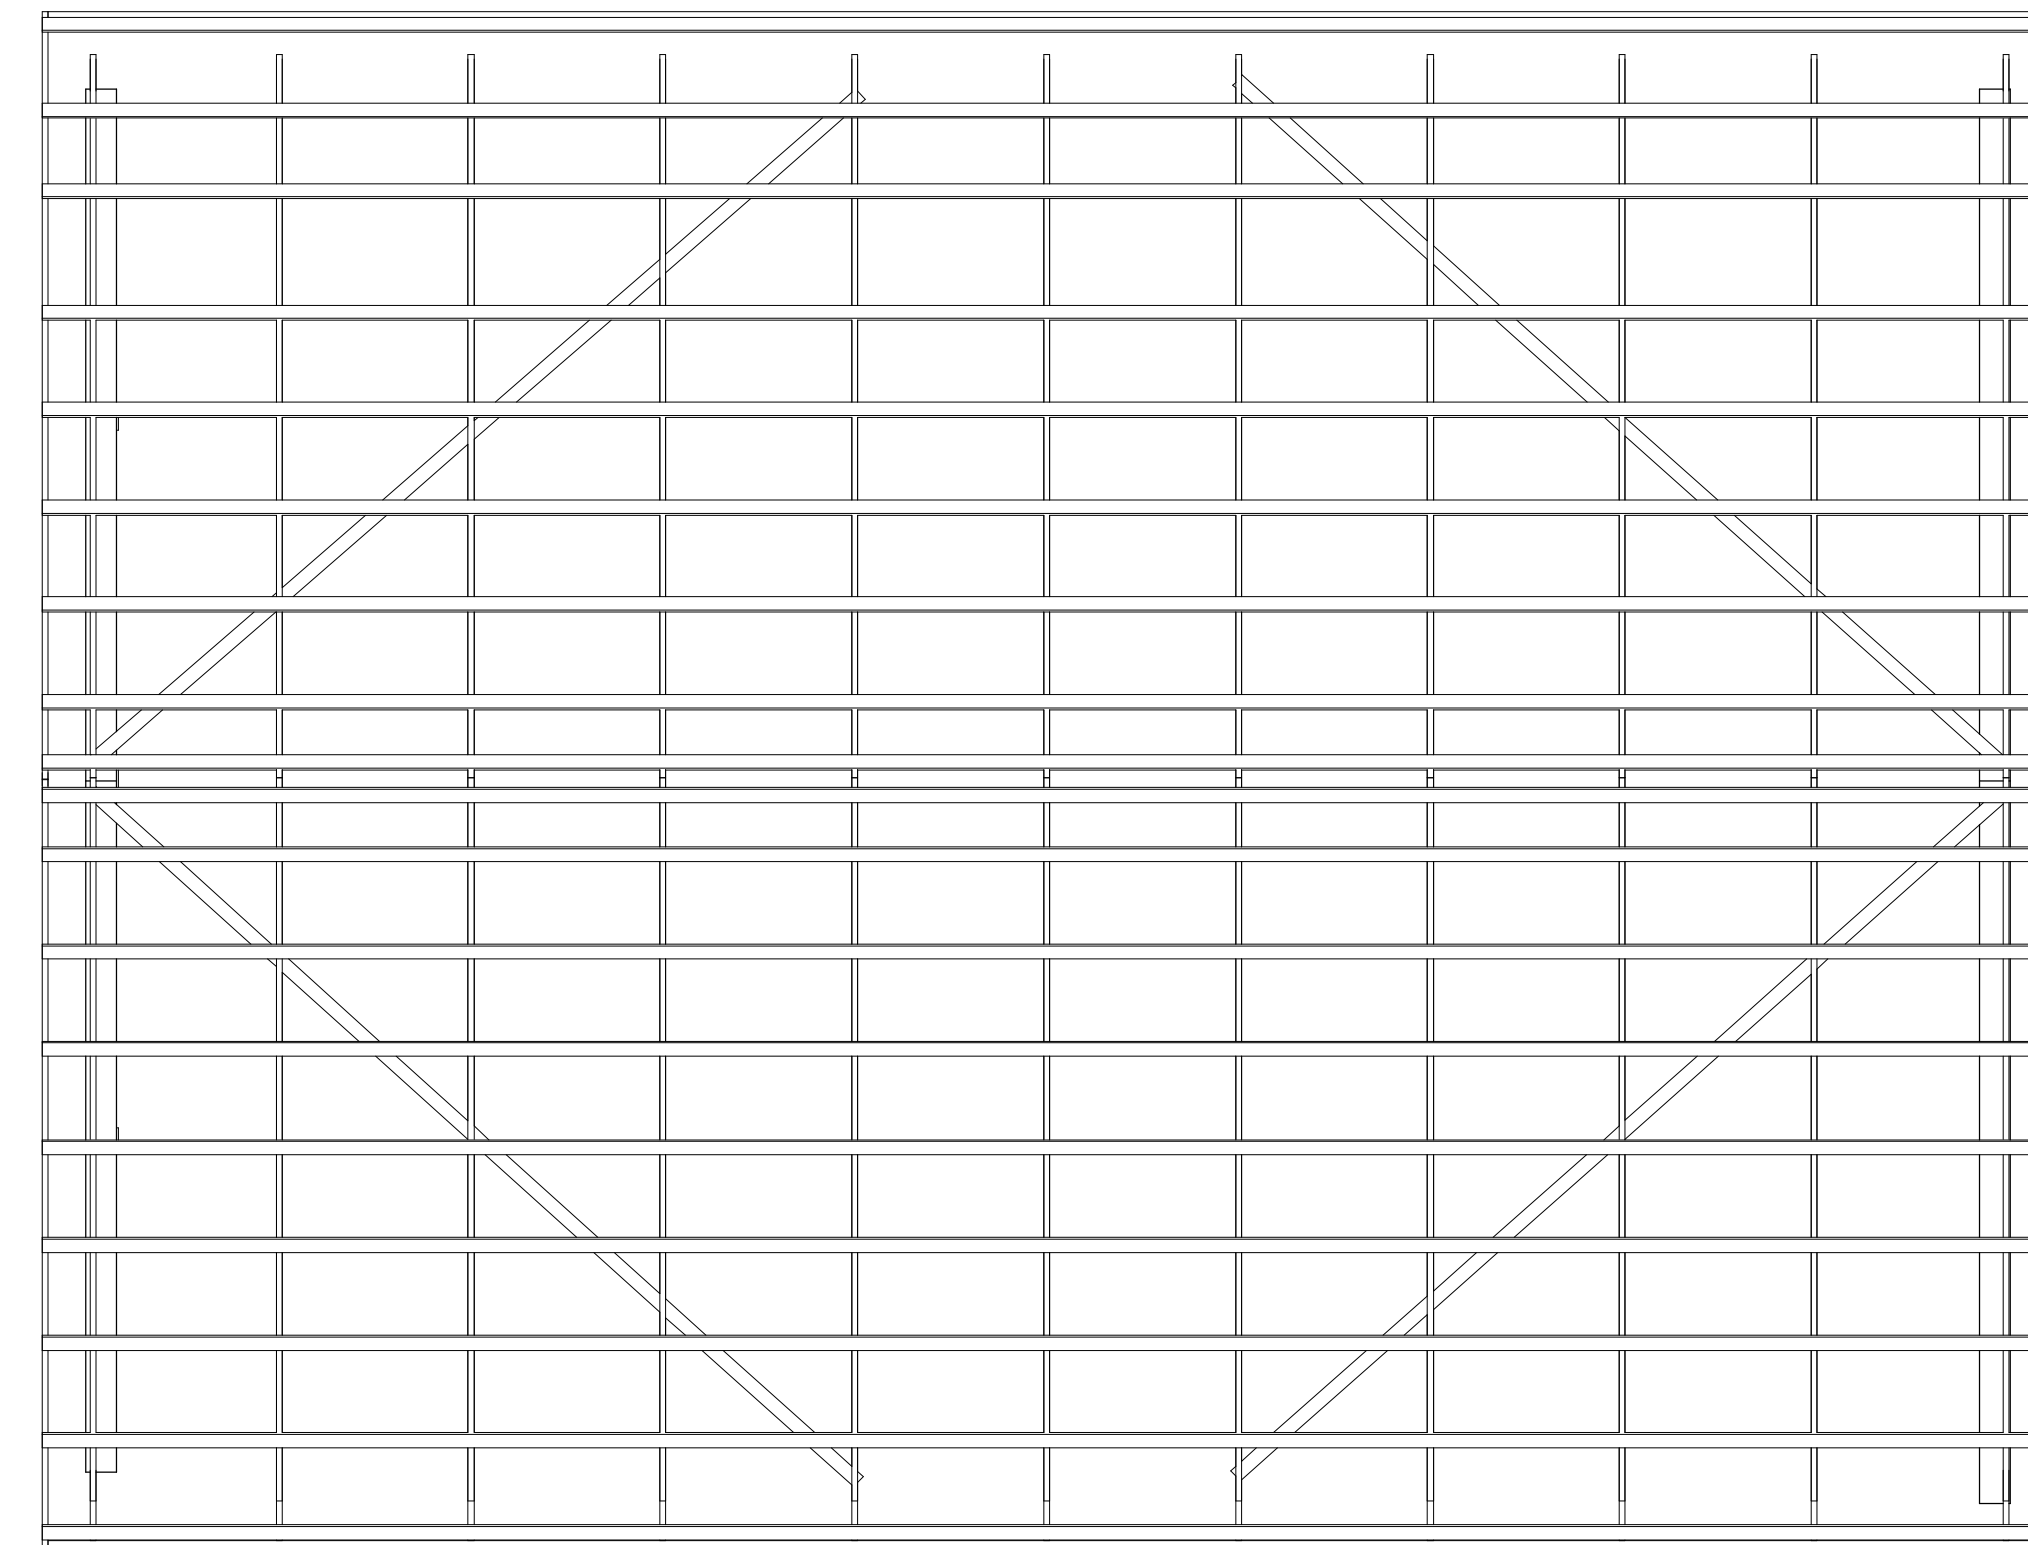

② Roof Framing Plan  
1/4" = 1'-0"

No.	Description	Date
	50% Review Plans	07/03/2018

**Roof/Truss Plan**

Project number	Project Number
Date	04/26/2016
Drawn by	Author
Checked by	Checker



A103

Scale 1/4" = 1'-0"

R&R DRAFTING  
llc.



29130 Taylor Rd  
Dennison, Ohio 44621  
Phone 330-440-2717  
Email rrdrafting@yahoo.com

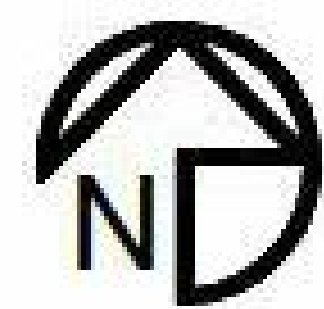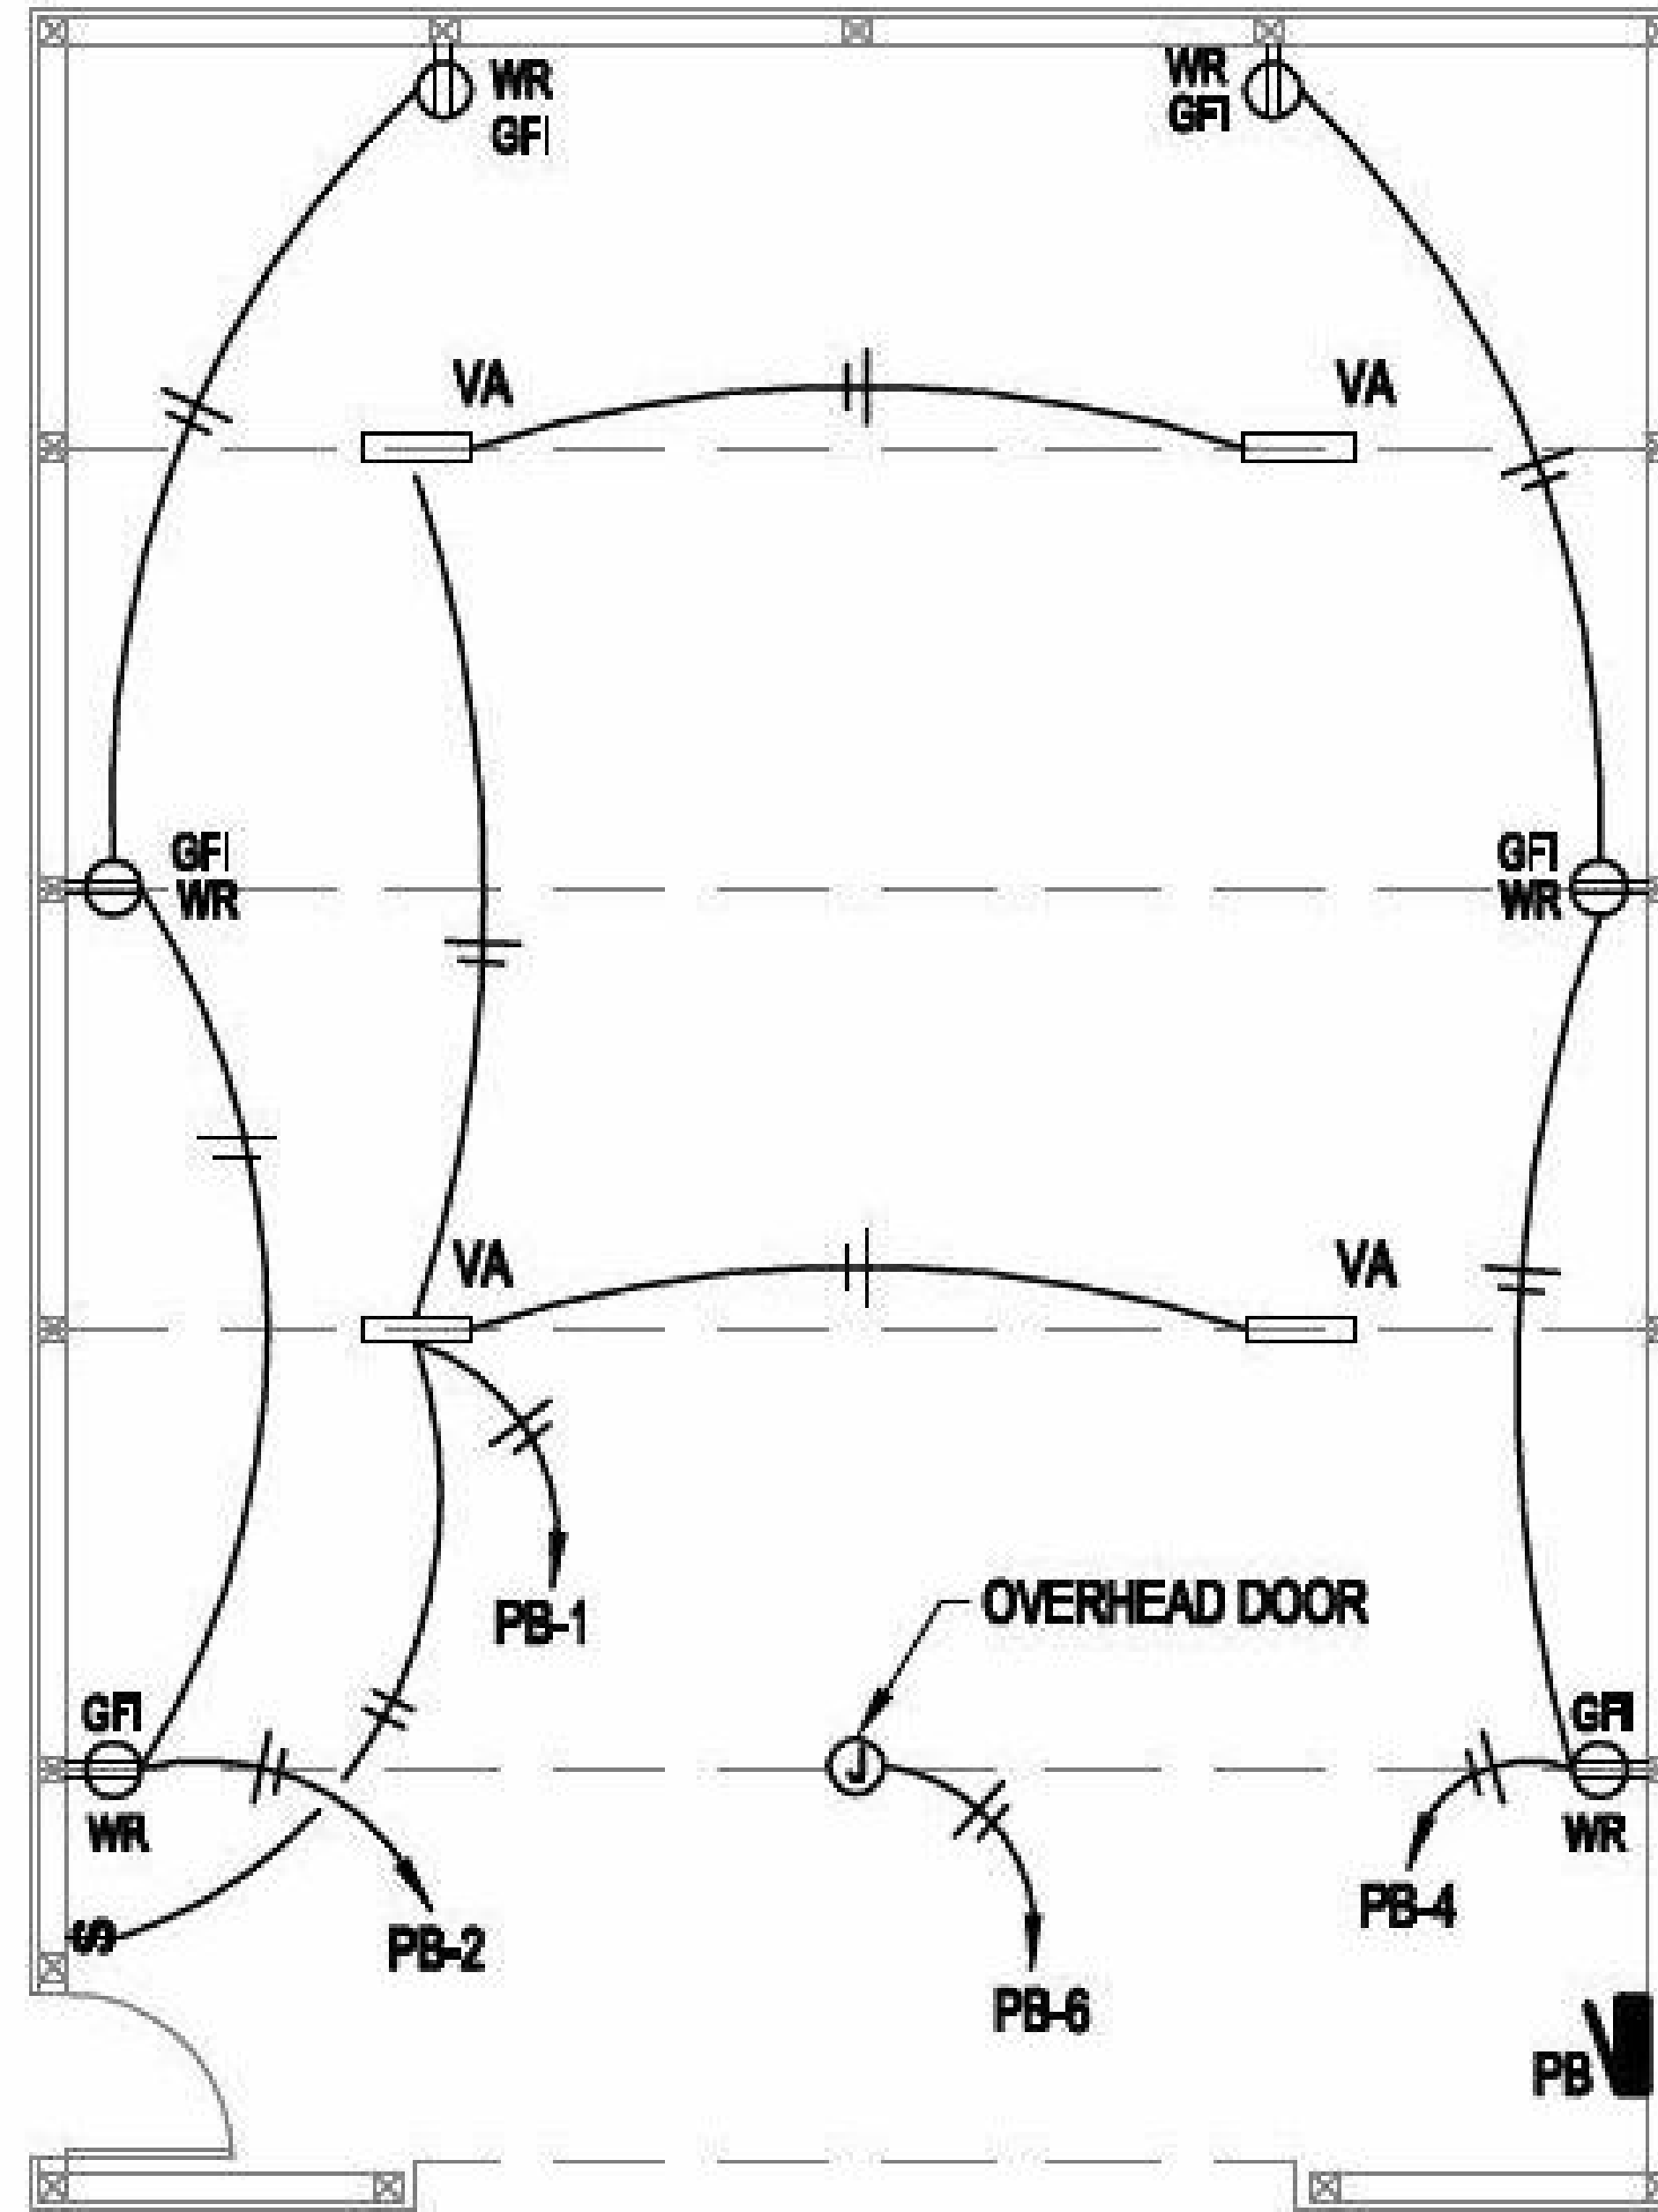

# ENLARGED POLE BUILDING ELECTRICAL PLAN

1/8" = 1'-0"

No.	Description	Date
	50% Review Plans	07/03/2018

<b>Electric</b>	
Project number	Project Number
Date	04/26/2016
Drawn by	Author
Checked by	Checker
<b>E100</b>	
Scale	